


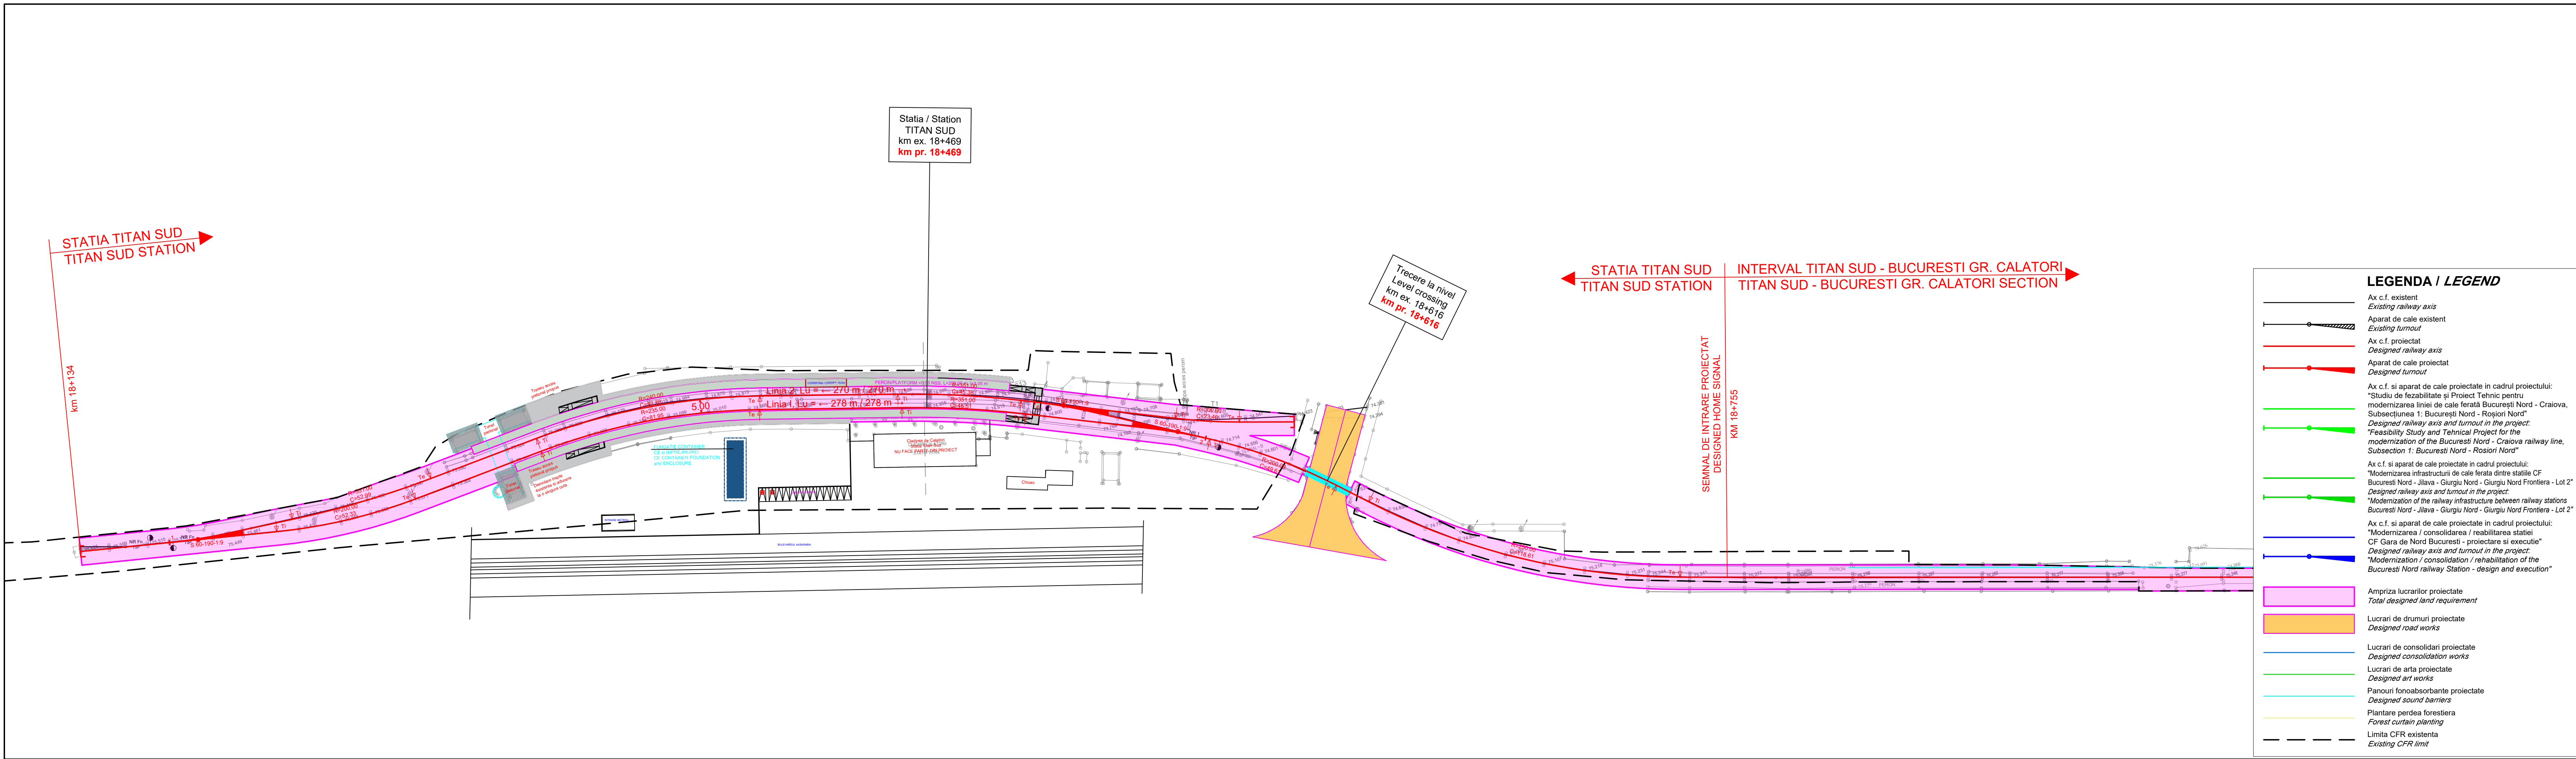

ENTITATE CONTRACTANTA CONTRACTING ENTITY								 C.N.C.F. "C.F.R." - S.A.			
CONTRACTANT CONTRACTOR								 Asocierea S.C. ISPCF S.A. - S.C. BAICONS IMPEX SRL			
				Nume Name				Data Date		Semnatura Signature	
Şef Proiect Project Manager				Viorel Gorgonetu				11.2024			
Verificat Checked				Ioana Crăciun				11.2024			
Proiectat Designed				Radu Crăciun				11.2024			
"Modernizarea liniilor şi instalaţiilor din Complexul Feroviar Bucureşti" Studiu de fezabilitate "Modernization lines and installations in the Bucharest Railway Complex Feasibility Study								Proiect / Project 38 / 2022			
								Faza / Phase S.F. F.S.			
Denumire / Title Plan de Situaţie / Site Plan km 18+134 - km 19+900								Scara / Scale 1:1000			
Codificare / Codification System COBU SF CFS DPS 00 00 072 R00											
Istoricul reviziilor / Revision History											
Rev.	Data/Date	Descriere Modificare / Modification description									
1											
2											
3											
4											