



SYMBOL LEGEND/LEGENDA SIMBOLURI

SYMBOL/SIMBOL	DESCRIPTION/DESCRIERE
	ELECTRICAL PANEL HELIPORT/CAZANO ELECTRICE HELIPORT
	COM. VOLT LIMITATOR WITH OVERVOLT PROTECTION SINGLE SOURCE, TERMINAL/COM. LIMITATOR CU SAU SURTENSIE, PROTECTIE SINGURA Sursa, TERMINAL
	COM. VOLT LIMITATOR WITH OVERVOLT PROTECTION SINGLE SOURCE, SINGLE SOURCE, TERMINAL/COM. LIMITATOR CU SAU SURTENSIE, PROTECTIE SINGURA Sursa, SINGURA Sursa, TERMINAL
	UNIFIED MONITORING NETWORK REFERENCE # PART OF 2 PARTS 100M
	ROOFMOUNT LIGHTING PROTECTOR WITH LIGHTS 30W/PROTECTORUL LUMINANT MONTAT CU LUMINA 30W
	SIGNAL BOARD LIGHT PROTECTOR WITH LIGHTS 50W (MINIMUM DISTANCE FROM PITCH 0.5 M) BOARD SIGNAL LIGHT PROTECTOR CU LUMINA 50W (Distanța MINIMA DE PITCH 0.5 M)

KEY MAP/CHIEE HARTA

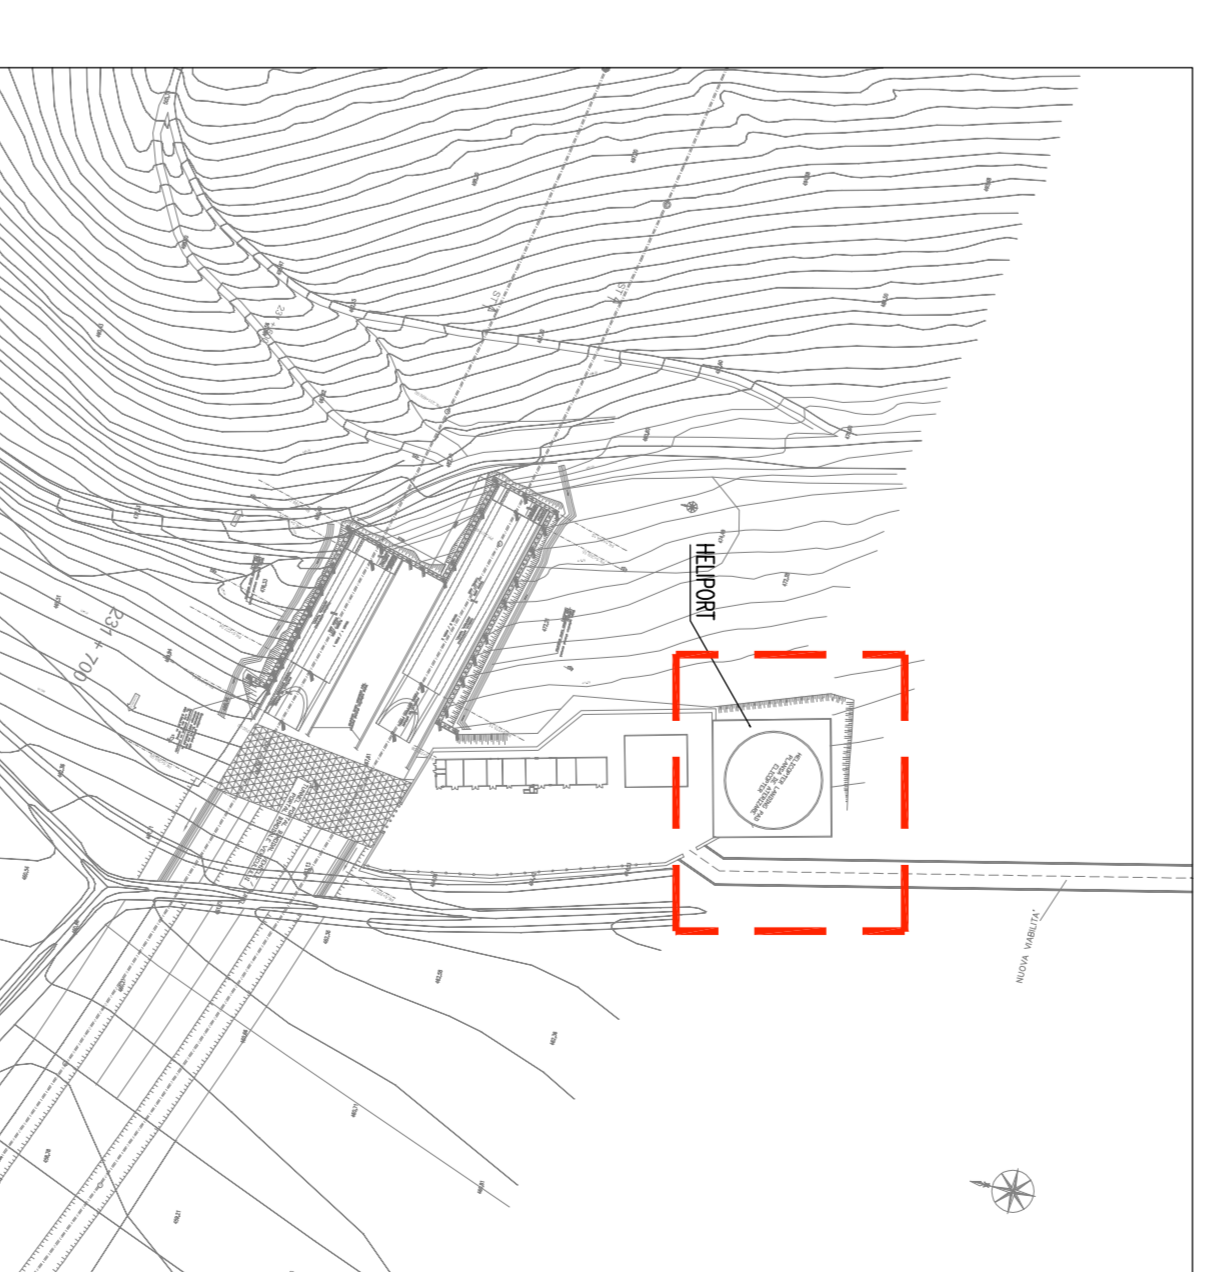

SINGLE-LINE DIAGRAM ELECTRICAL HELIPORT Q-EL/SINGLE-LINE DIAGRAMA ELECTRICE HELIPORT Q-EL

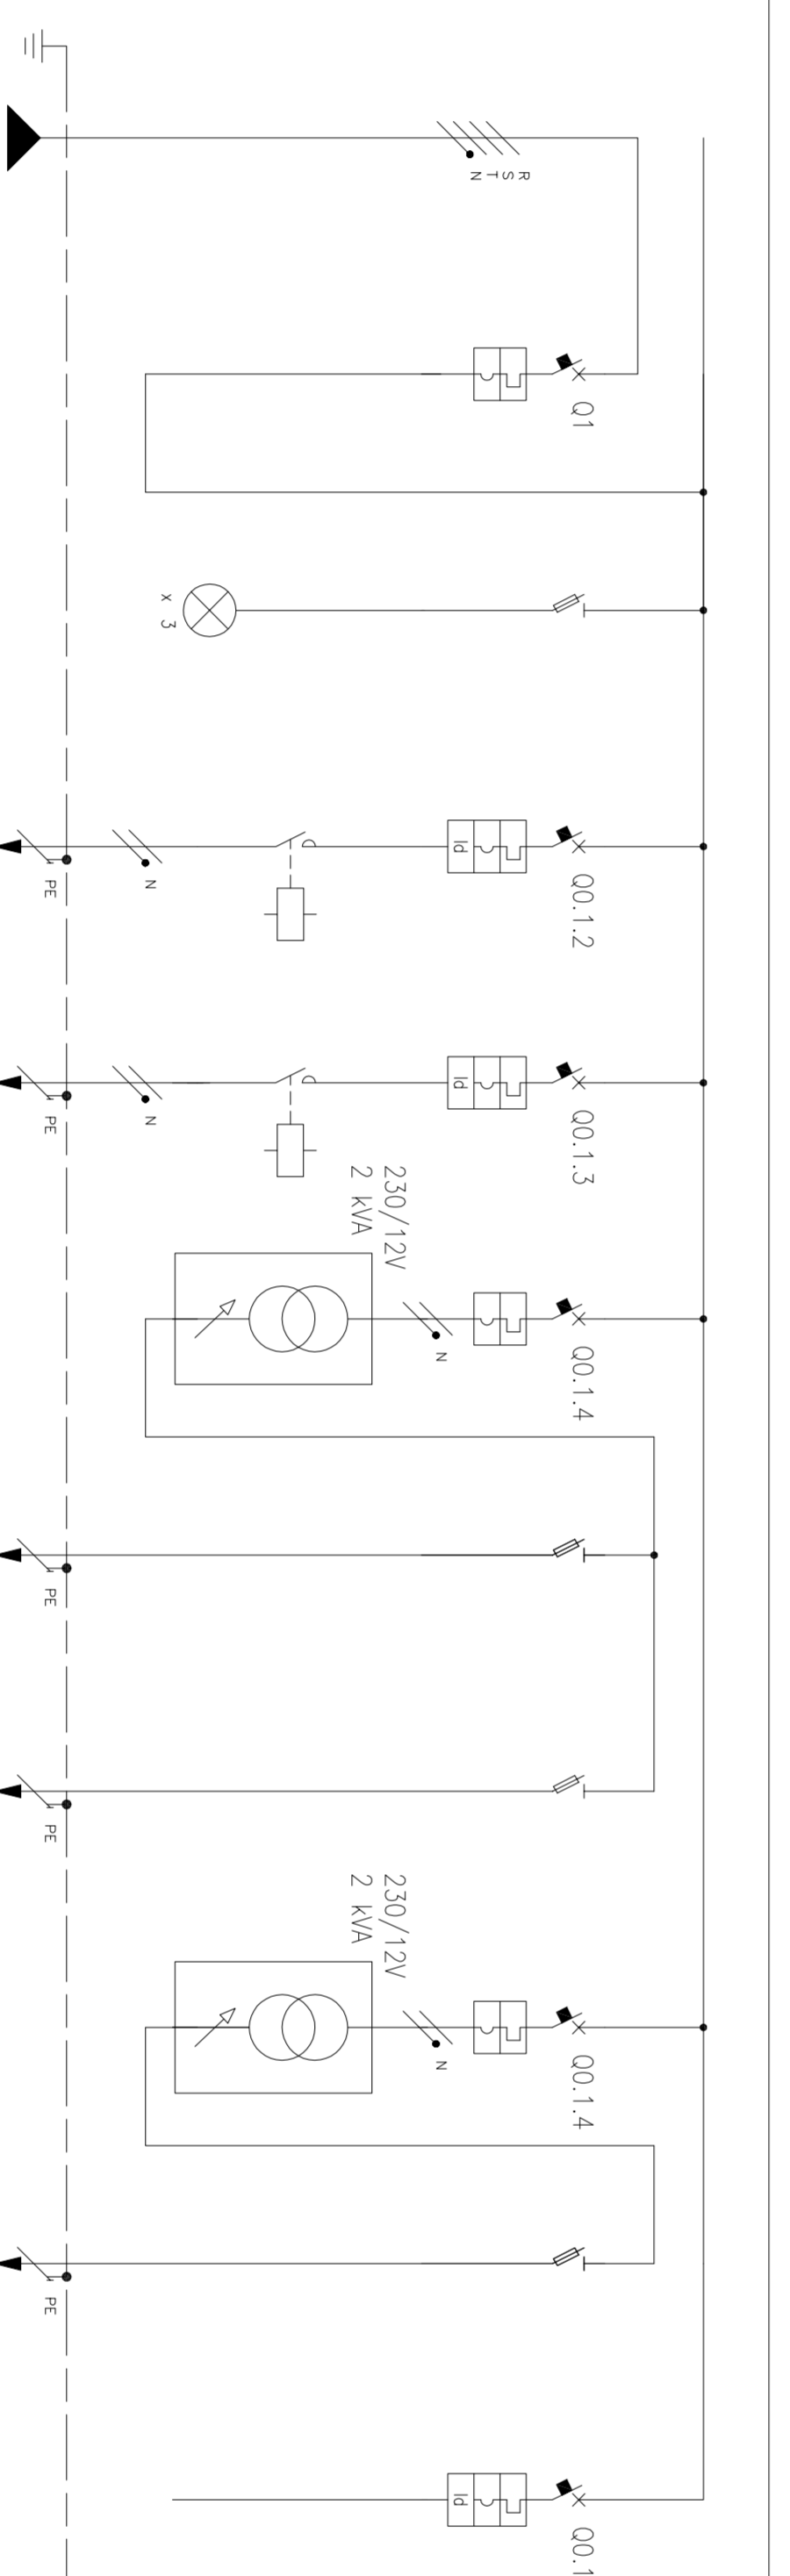

ITEM	DESCRIPTION	QUANTITY	UNIT	REMARKS
1	10kV/0.4kV TRANSFORMER	1	PC	
2	10kV/230V TRANSFORMER	1	PC	
3	10kV/230V TRANSFORMER	1	PC	
4	10kV/230V TRANSFORMER	1	PC	
5	10kV/230V TRANSFORMER	1	PC	
6	10kV/230V TRANSFORMER	1	PC	
7	10kV/230V TRANSFORMER	1	PC	
8	10kV/230V TRANSFORMER	1	PC	
9	10kV/230V TRANSFORMER	1	PC	
10	10kV/230V TRANSFORMER	1	PC	

CLIENT / CLIENT
CFR
C.N.C.F. "C.F.R." - S.A.

CONSULTANT / CONSULTANT
TRUZEAN
Wilson
OBREMAYER
TECHNIC

PROIECTANTII
 R. LUTZA
 C. GAMBELLI
 C. GAMBELLI
 P. ANDOIO

PROIECT/PROIECT
 2023/07/25/2023
 P.111, T.15

DATE
 Date: 2023/07/25
 Approved/Contratant: [Signature]
 Approved/Consultant: [Signature]

PROIECT/PROIECT
 2023/07/25/2023
 P.111, T.15

CONDITII / CONFIDENCE SYSTEM
 Scale: 1:500
 L07
 Nk./Ns