

MEDICAL CARE BUILDING GROUND FLOOR PLAN/CLADIRE DE SANATATE PLAN DE PARTIER – SCALE 1:100

MEDICAL CARE BUILDING LOCAL LEGEND/ LEGENDA LOCAL CLADIRE DE SANATATE	
LOCAL	DESCRIPTION/DESCRIERE
1	WIRING LOCAL
2	LOCAL ACOPERIRE
3	SUBSTANT
4	W.C.
5	Medical/clinic


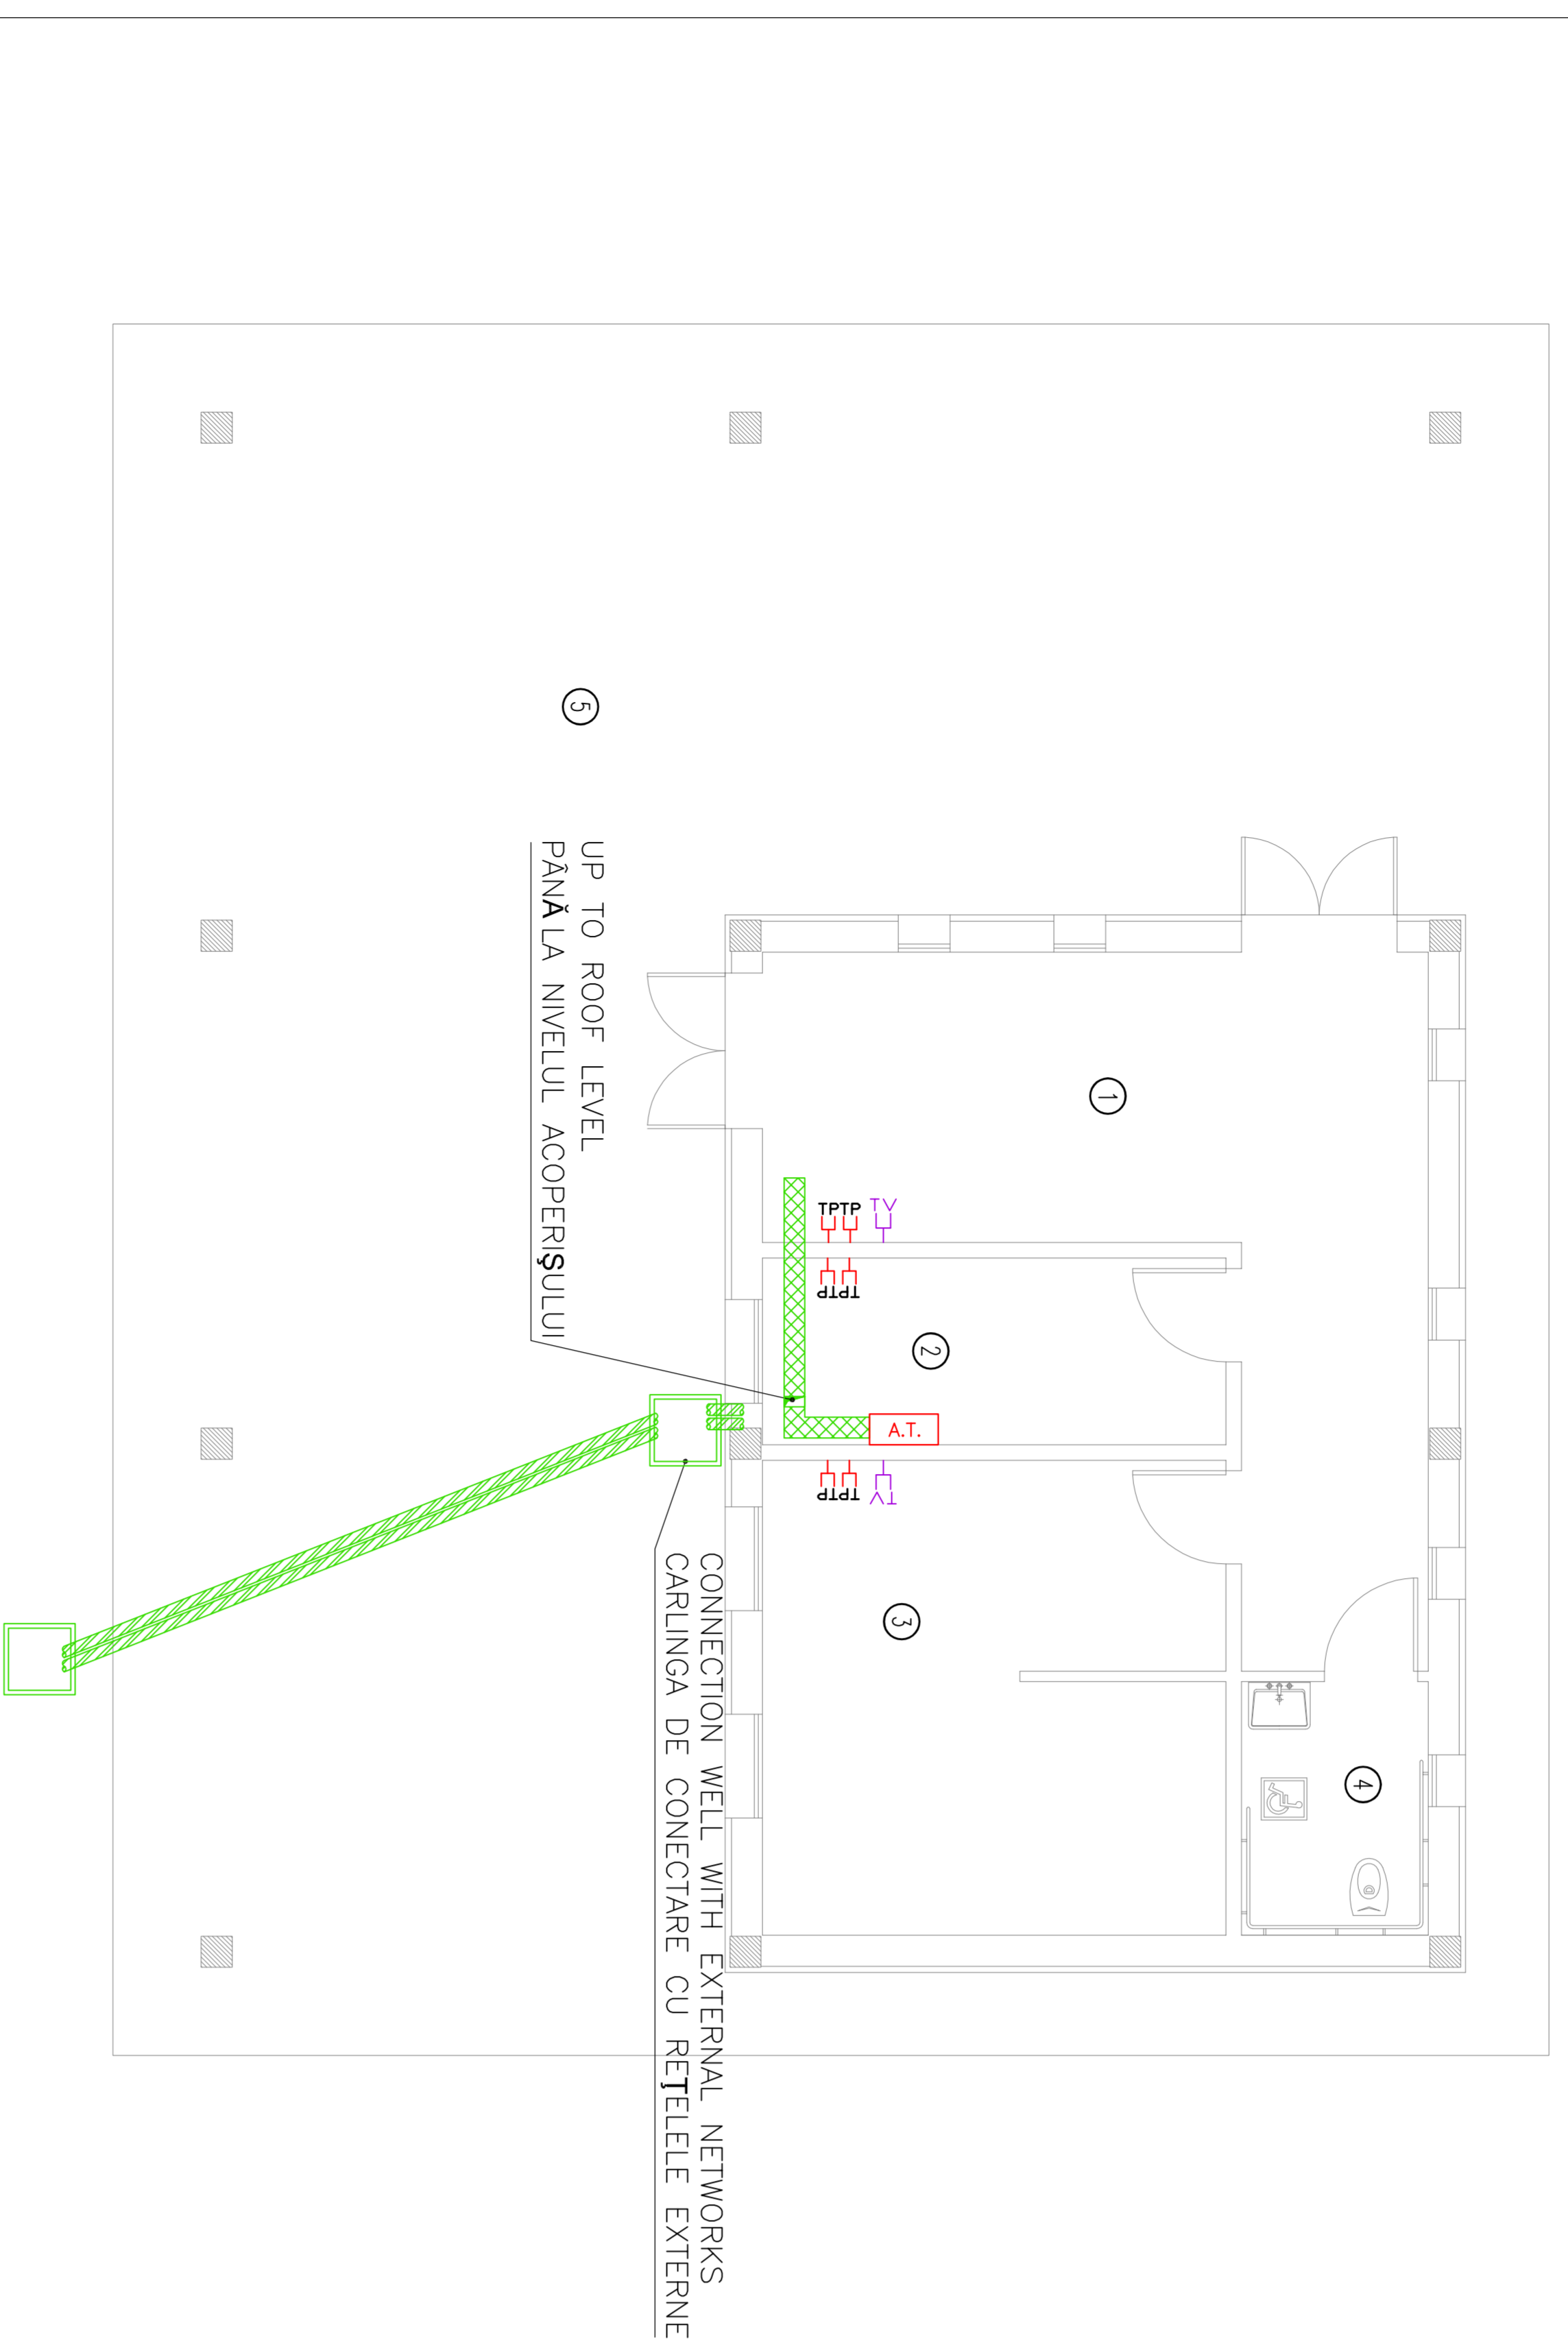


DIAGRAM TV SYSTEM/DIAGRAME SISTEMUL DE TV

CABLE FOR TRANSMISSION OF ANALOG AND DIGITAL TV SIGNALS/  
CABLU DE TRANSMISIE A SEMNALULUI TV ANALOGIC SI DIGITAL

GROUND FLOOR/PLAN DE PARTIER

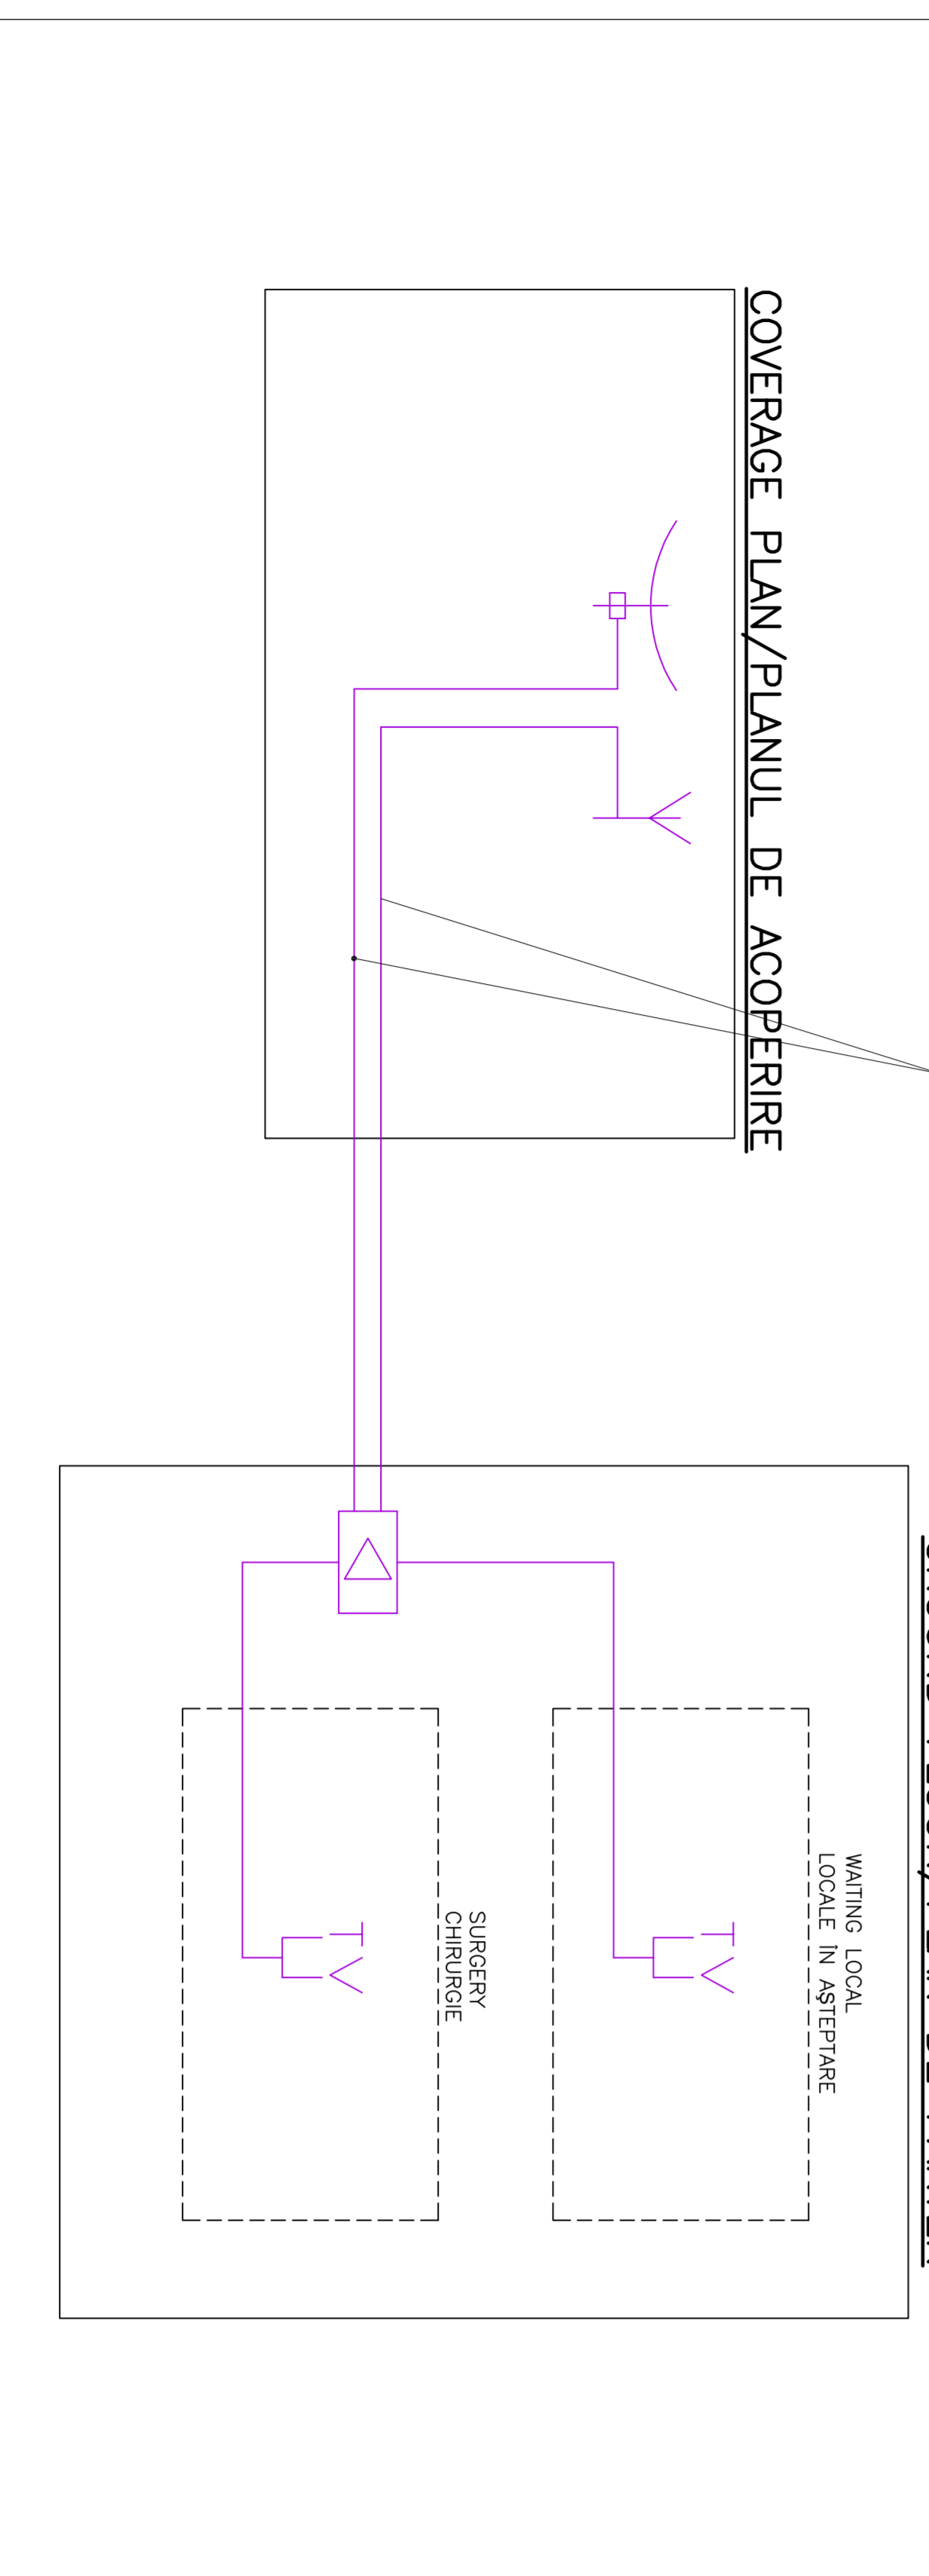

MEDICAL CARE BUILDING COVERAGE PLAN /CLADIRE DE SANATATE PLANUL DE ACOPERIRE – SCALE 1:50


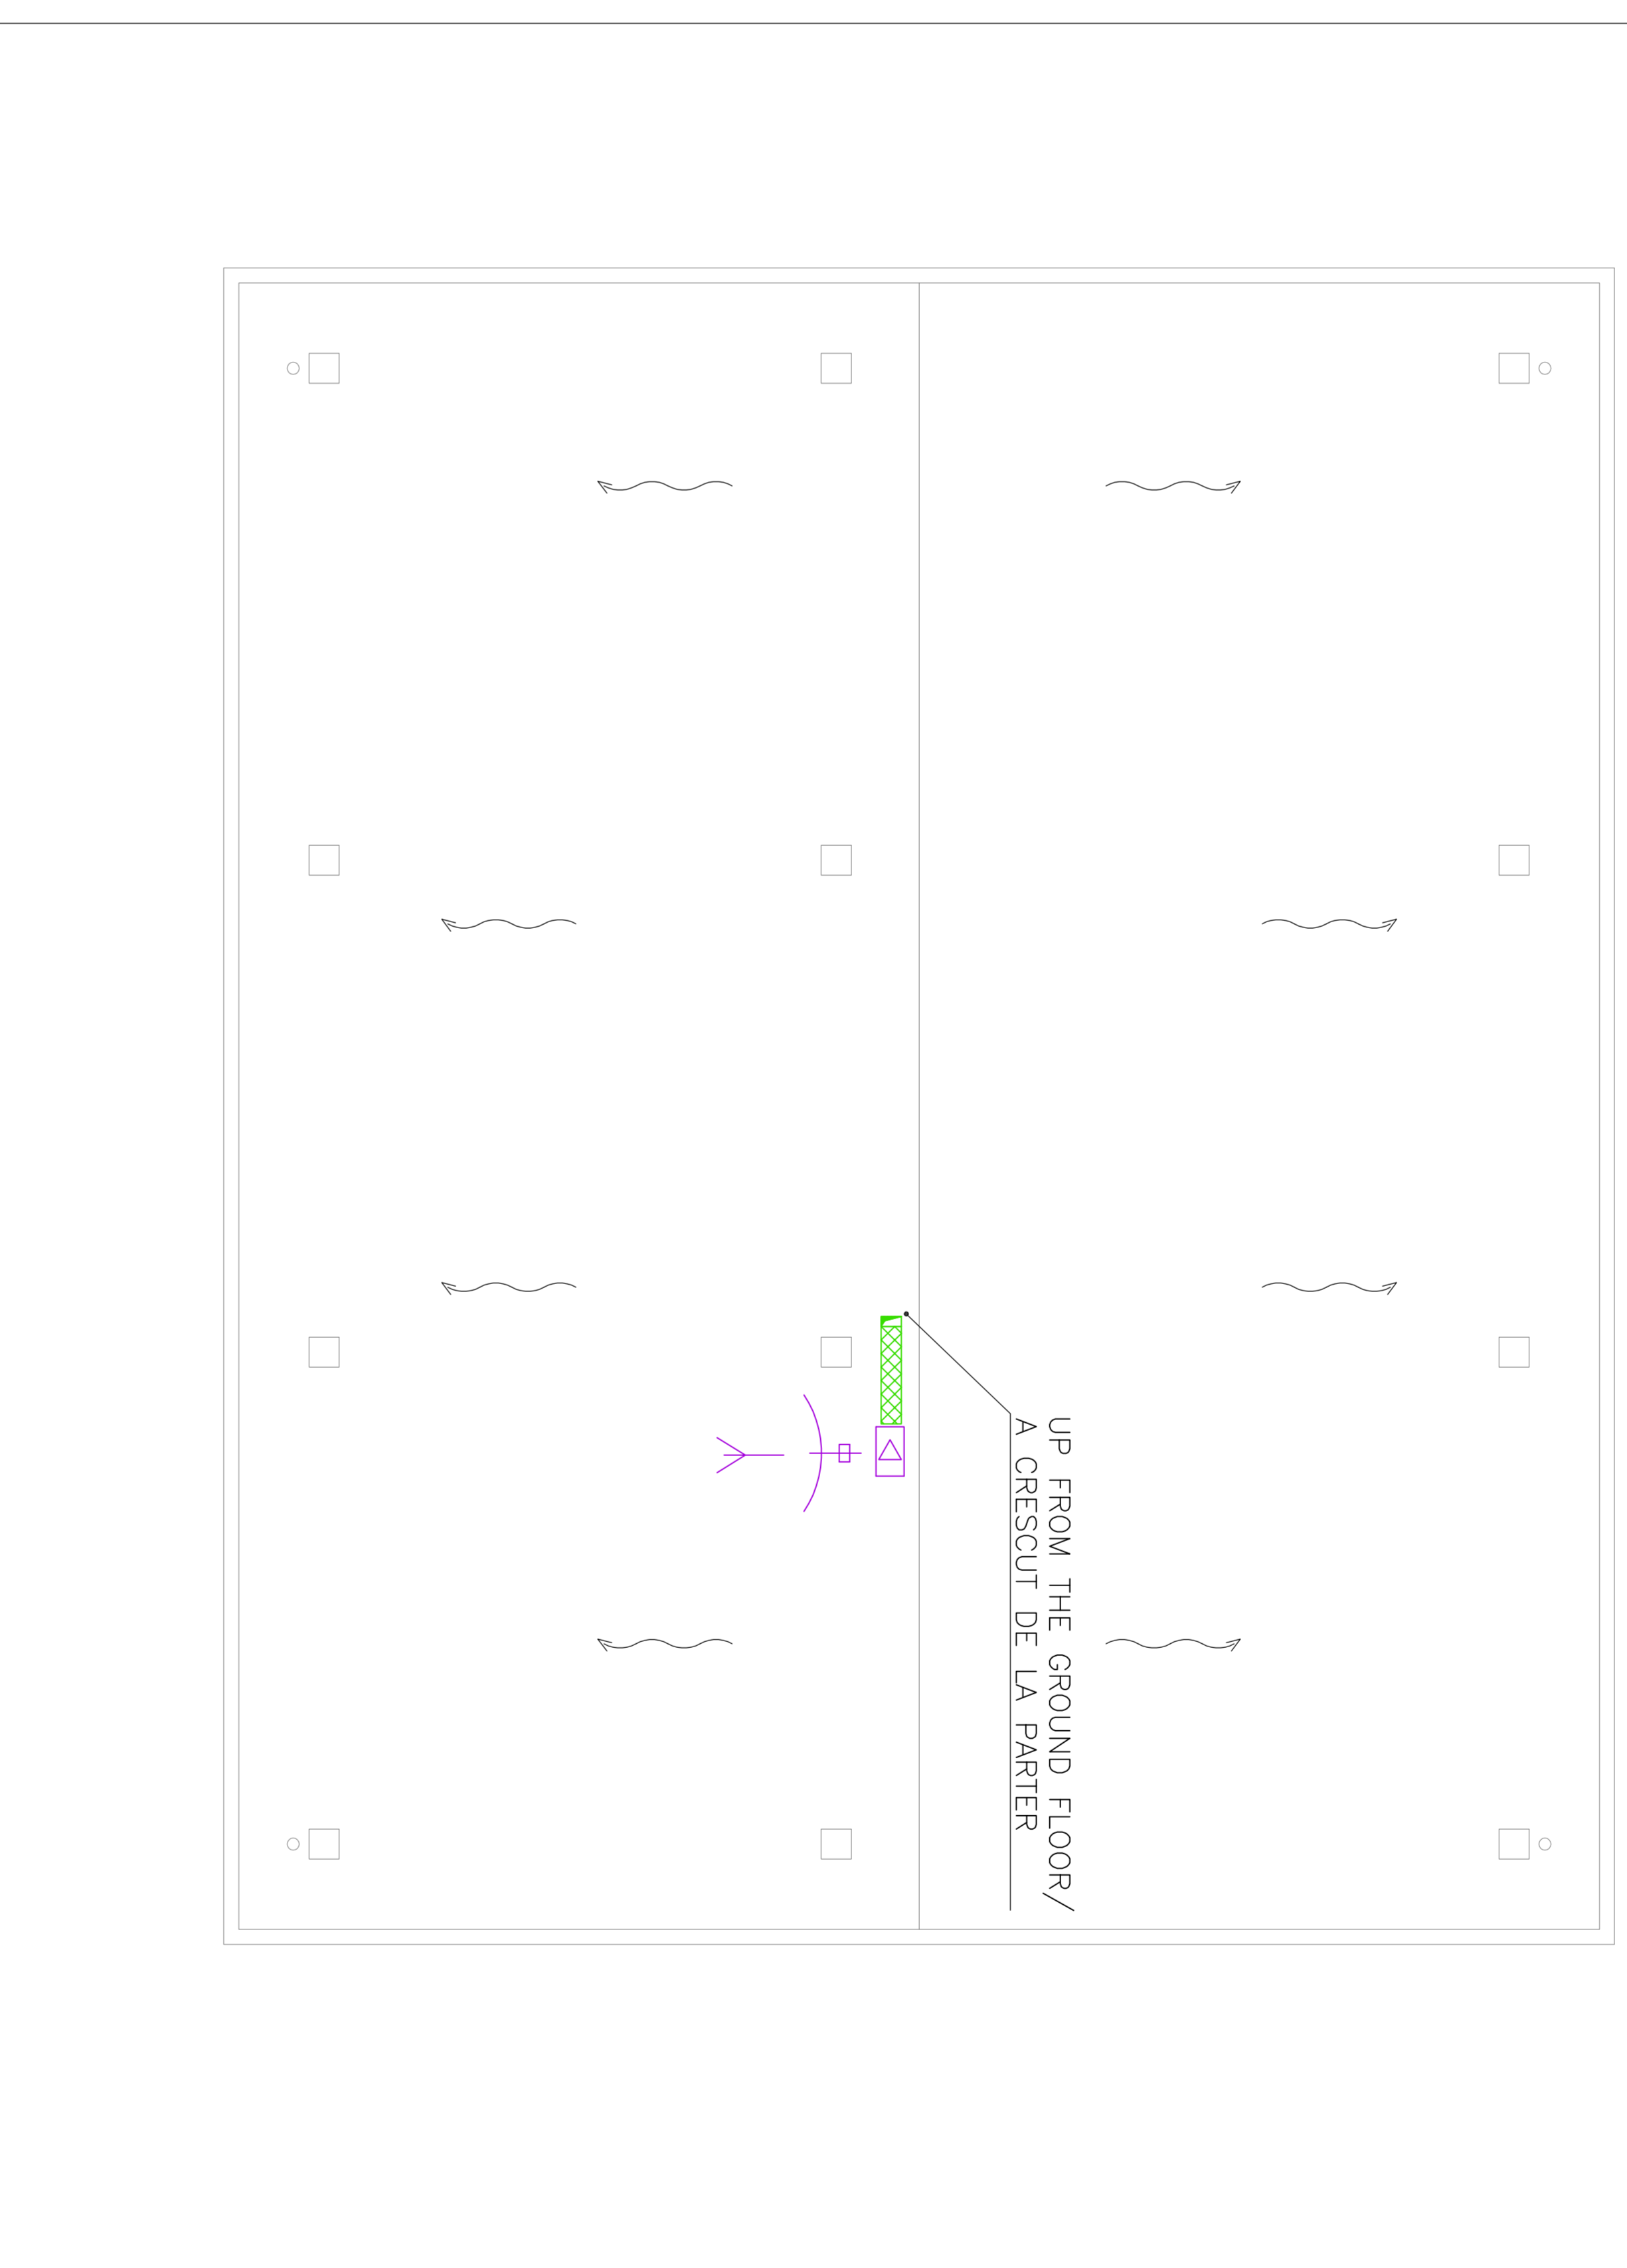


DIAGRAM VOICE-DATA SYSTEM/DIAGRAME SISTEMUL DE VOCE-DATA


GROUND FLOOR/PLAN DE PARTIER

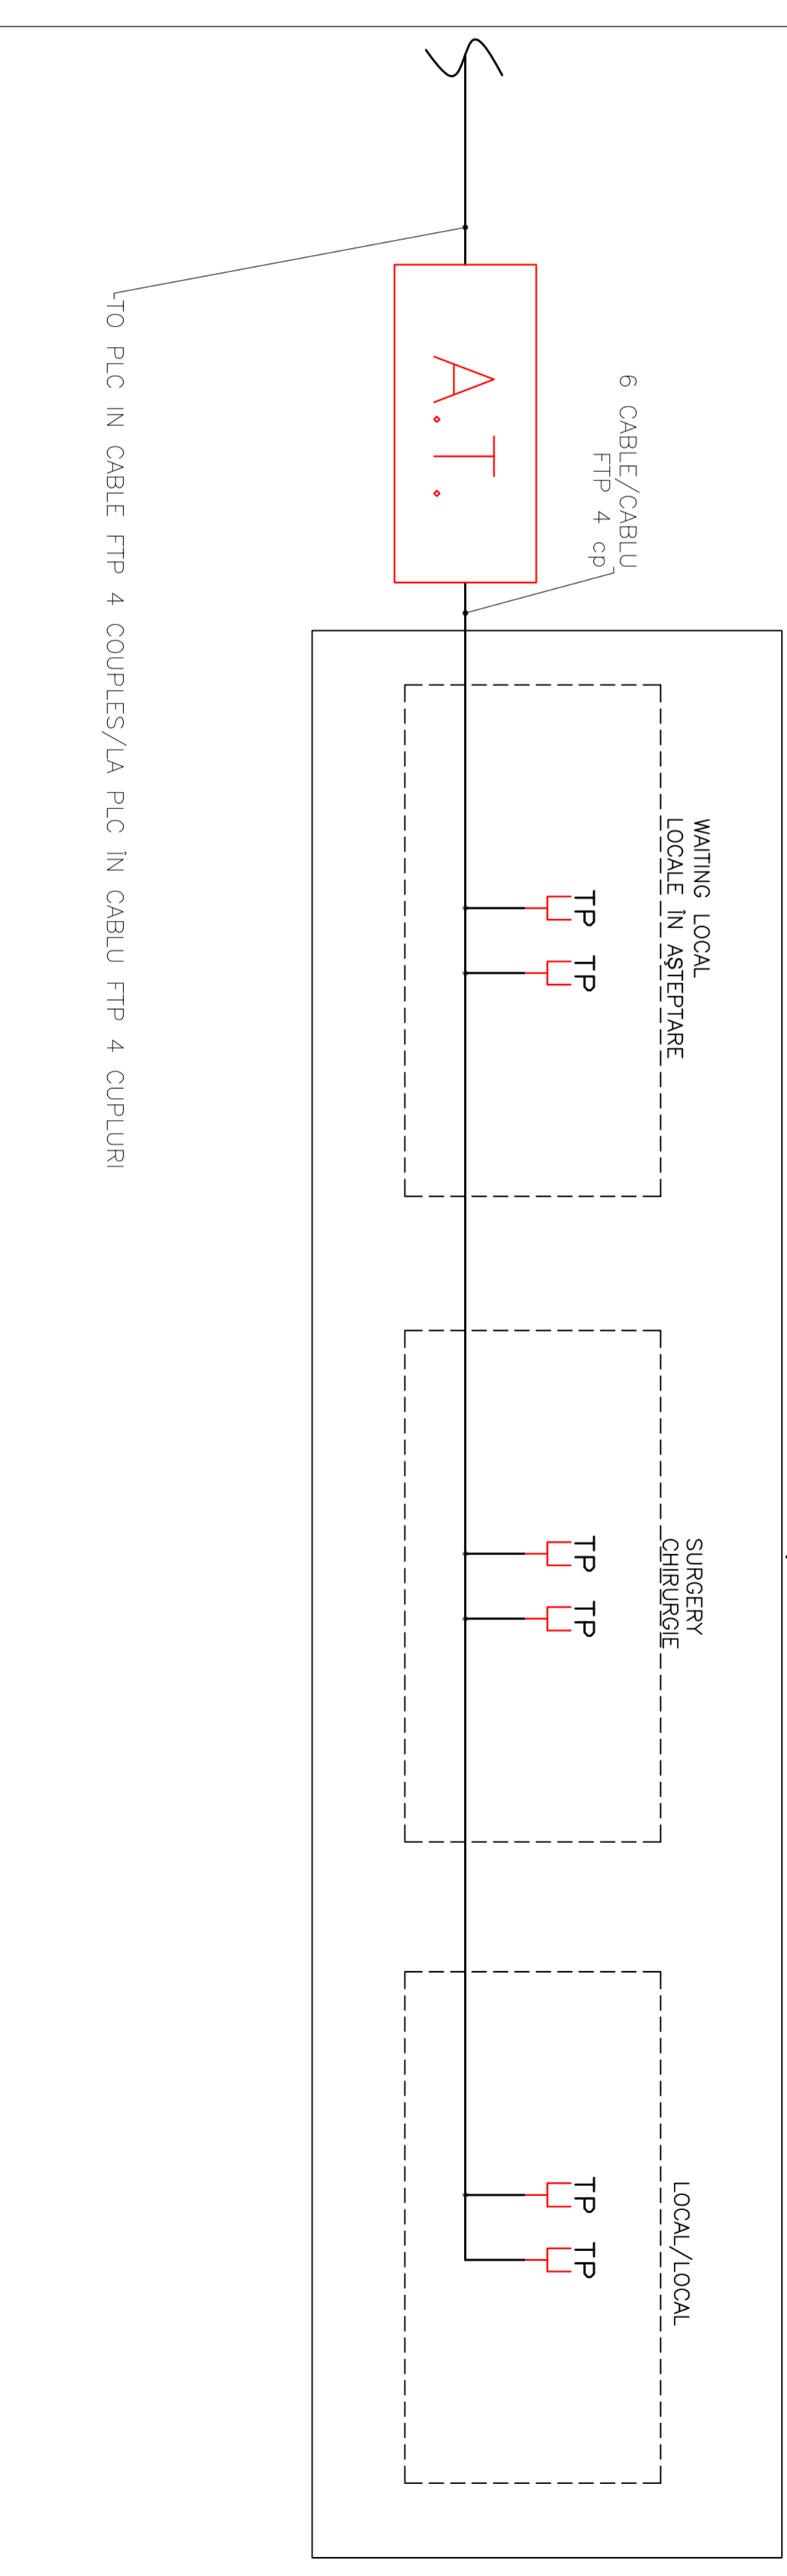

SYMBOL LEGEND/LEGENDA SIMBOLURI

SYMBOL/SIMBOLUL	DESCRIPTION/DESCRIERE
TP	VOICE-DATA RJ45 SOCKET/PIAZA VOCE-DATA RJ45
	TERRISTRICAL TV ANTENNA/TERESTRIU TV ANTENA
	SATELLITE TV ANTENNA/TV-SATELIT ANTENA
	SOCKET GROUP CONNECT FROM A SOCKET OF TV ANTENNA OF TYPE TERRISTRICAL TV AND A SOCKET ANTENNA SATELIT/CABLU DE PRIZE ESTE LATA DE LA REZEA DE ANTENA TV DE TIP TERESTRIU SI DE TIP TV SATELIT
	CABINET FOR VOICE-DATA STRUCTURED CABLE/CABINETUL VOCE-DATA RACORD STRUCTURAT
	SATELITE TV ANTENNA SYSTEM TV/SATELIT DE DISTRIBUIE DE AMPLIFICARE TV
	CABLE REINFORCED STEEL GALVANIZED 200X100 MM FOR SPECIAL SYSTEM DISTRIBUTION
	CABLE REINFORCED STEEL GALVANIZED 200X100 MM FOR TV SYSTEM DISTRIBUTION SPECIAL
	POLYETHYLENE CONDUIT FOR EXTERNAL USE WITH 110 mm
	100% SHIELDING SIGNAL SYSTEM 5 (110 mm)

KEY MAP/HARTA CHEIE

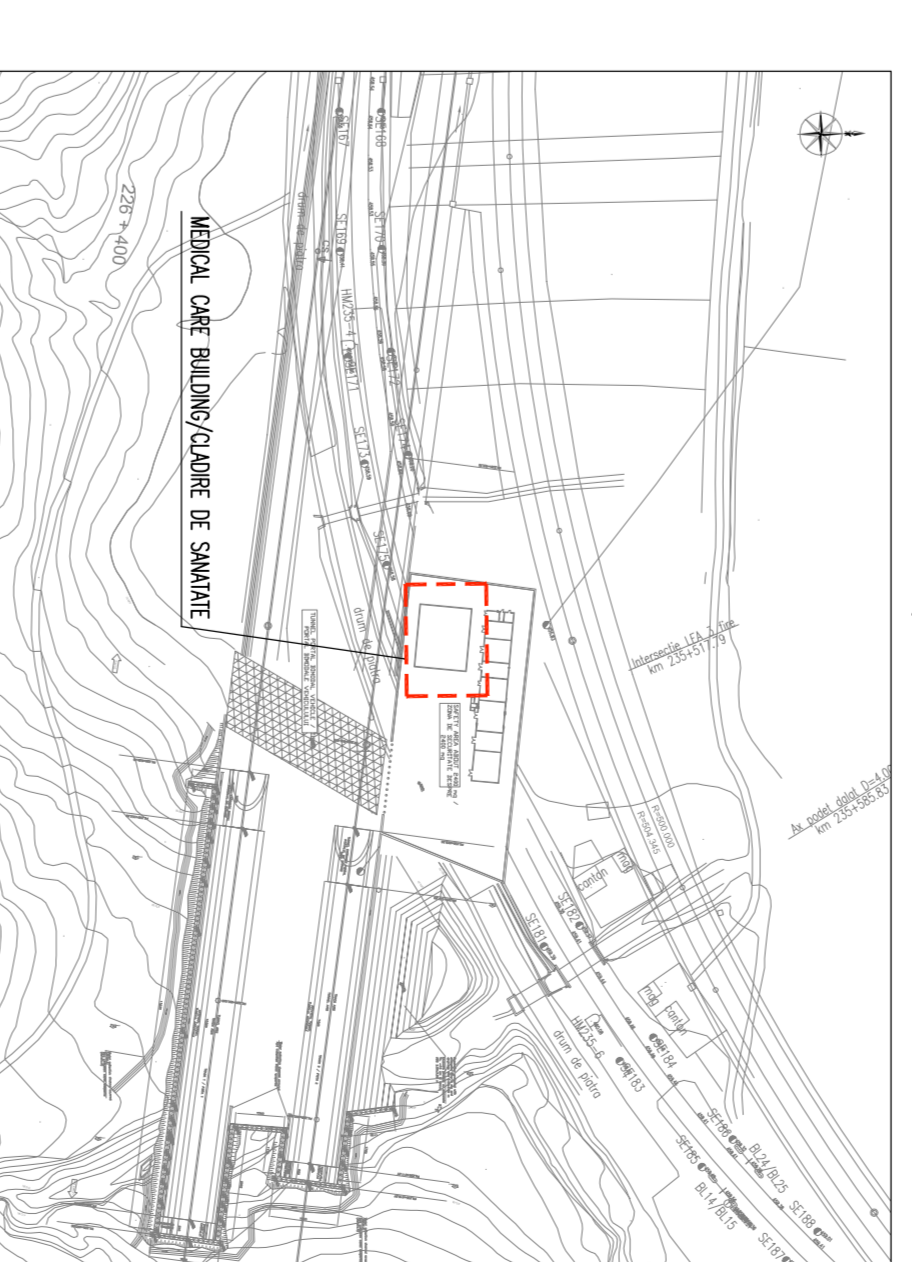

D					
C					
B					
A					

Date: \_\_\_\_\_  
 Modificari/Modificari: \_\_\_\_\_  
 Proiectant: \_\_\_\_\_  
 Desene: \_\_\_\_\_  
 Autorizati/Validat: \_\_\_\_\_  
 Data: \_\_\_\_\_

**GOVERNUL ROMANIEI**  
**ROMANIA**  
**PROIECT FINANCIAT DE UNIUNEA EUROPEANA**  
**SPERANZA IN VIITOR**

<b>CLIENT / CLIENT</b>	<b>C.M.C.F. - C.F.R. - S.A.</b>
------------------------	---------------------------------

<b>CONSULTANT / CONSULTANT</b>	<b>TECHNIC</b>
Approved: R. Lizza Project manager: C. Ghimbali Section Coordinator: C. Ghimbali Checked: C. Ghimbali Total Project: P. Amadio Designer: _____ Subcontractor responsible: _____	Date: _____ Serviciu: _____ Serviciu: _____ Serviciu: _____

<b>SUBCONSULTANT / SUBCONSULTANT</b>	
Approved: _____ Project manager: _____ Section Coordinator: _____ Checked: _____ Total Project: _____ Designer: _____ Subcontractor responsible: _____	Date: _____ Serviciu: _____ Serviciu: _____ Serviciu: _____

Realizarea liniei de cablu fibra optică - Serviciu parte componentă a contractului IV Pan European, per Secțiunea I. Serviciu - Serviciu  
 Rehabilitation of the railway from Europe - Serviciu parte componentă a contractului IV Pan European, per Secțiunea I. Serviciu - Serviciu  
 Section I. Serviciu - Serviciu

Denumire desen / Drawing Title: **TUNEL/TUNELUL HOMOROD**  
 Proiect/Project: \_\_\_\_\_  
 Serviciu: \_\_\_\_\_  
 P.11.1.1.D.

Conditiile / Conditions System	Scale: 1:500	1:07	N./Nb.
E A S 1	0 1	C 1 2	L X T S 2 0 7 8 9 0 0 4 0