

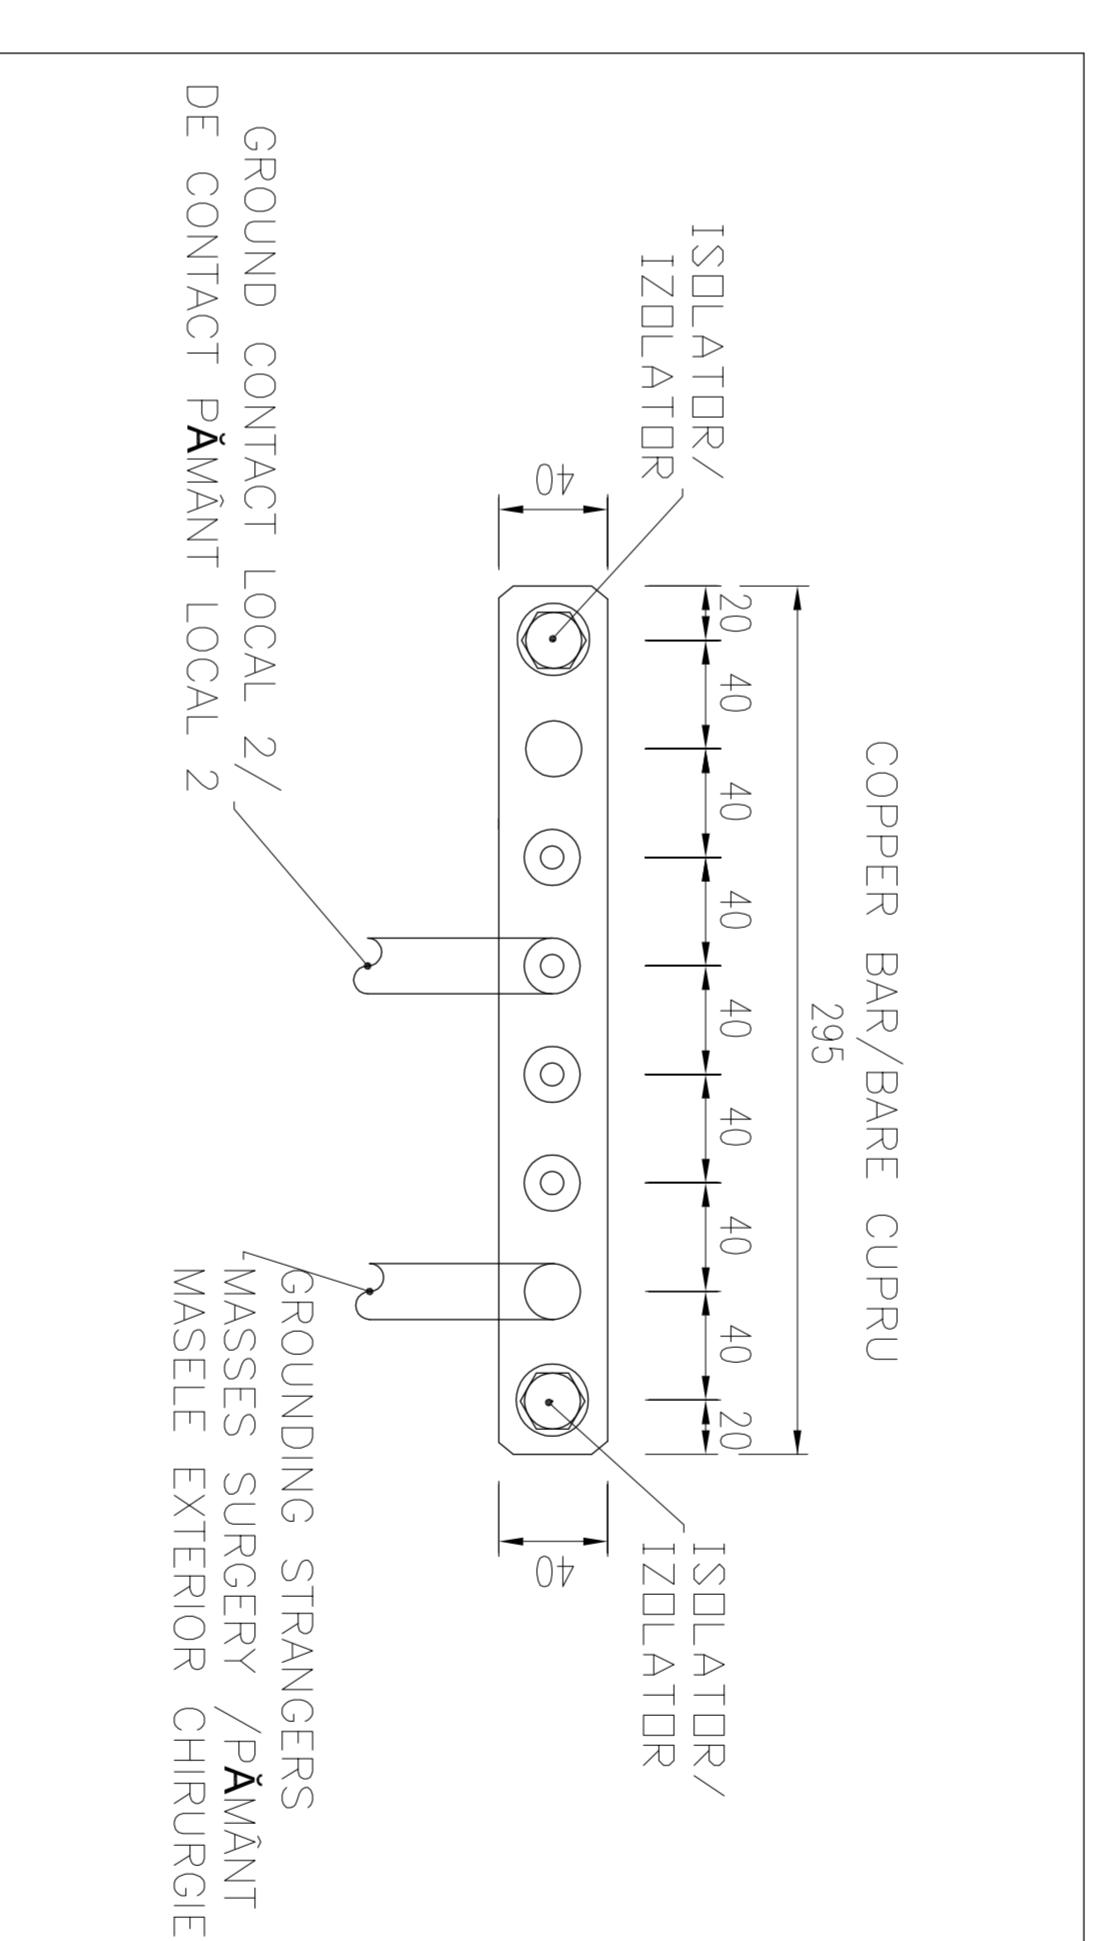
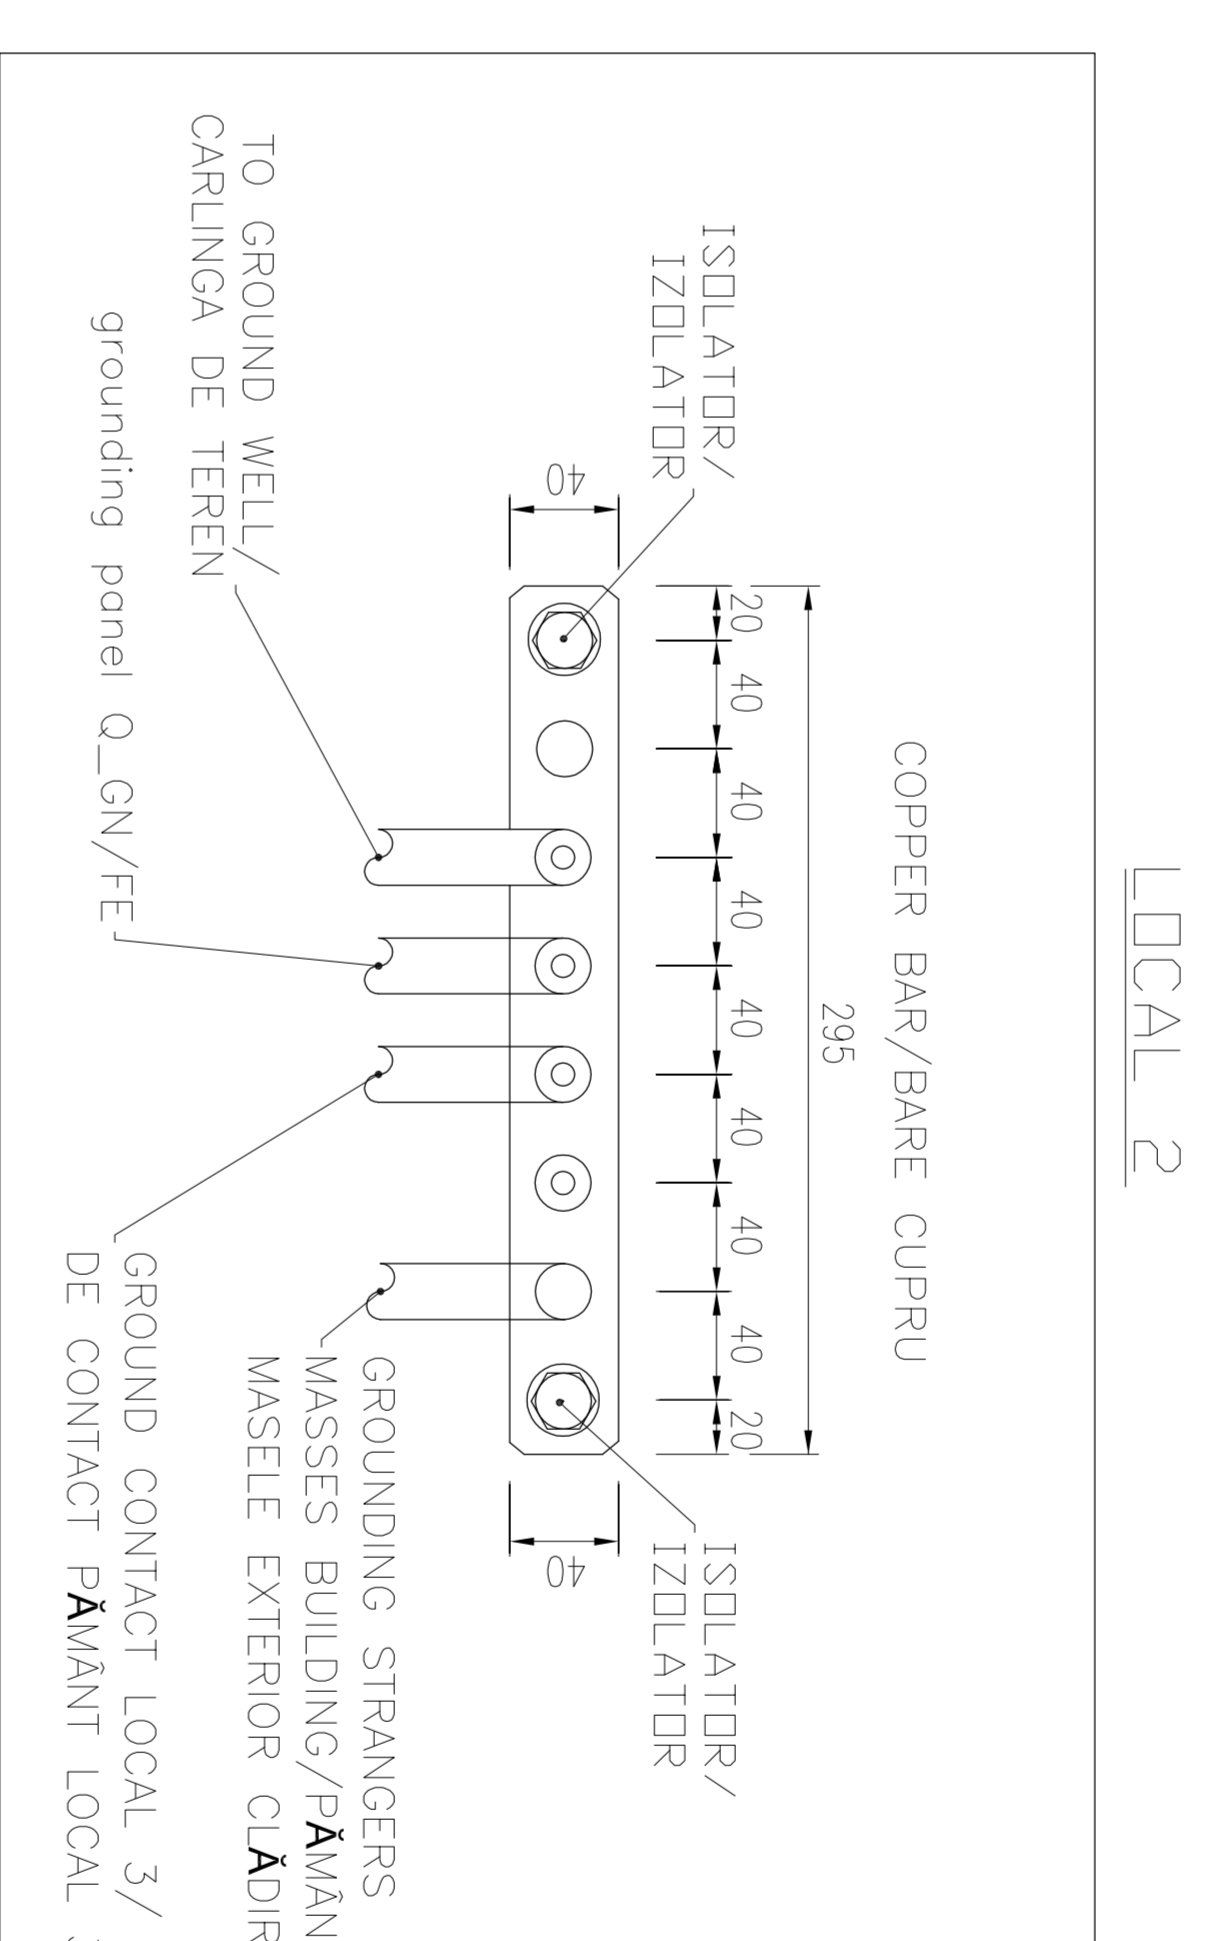


MEDICAL CARE BUILDING GROUND FLOOR PLAN/CLADIRE DE SANATATE PLAN DE PARTER - SCALE 1:50

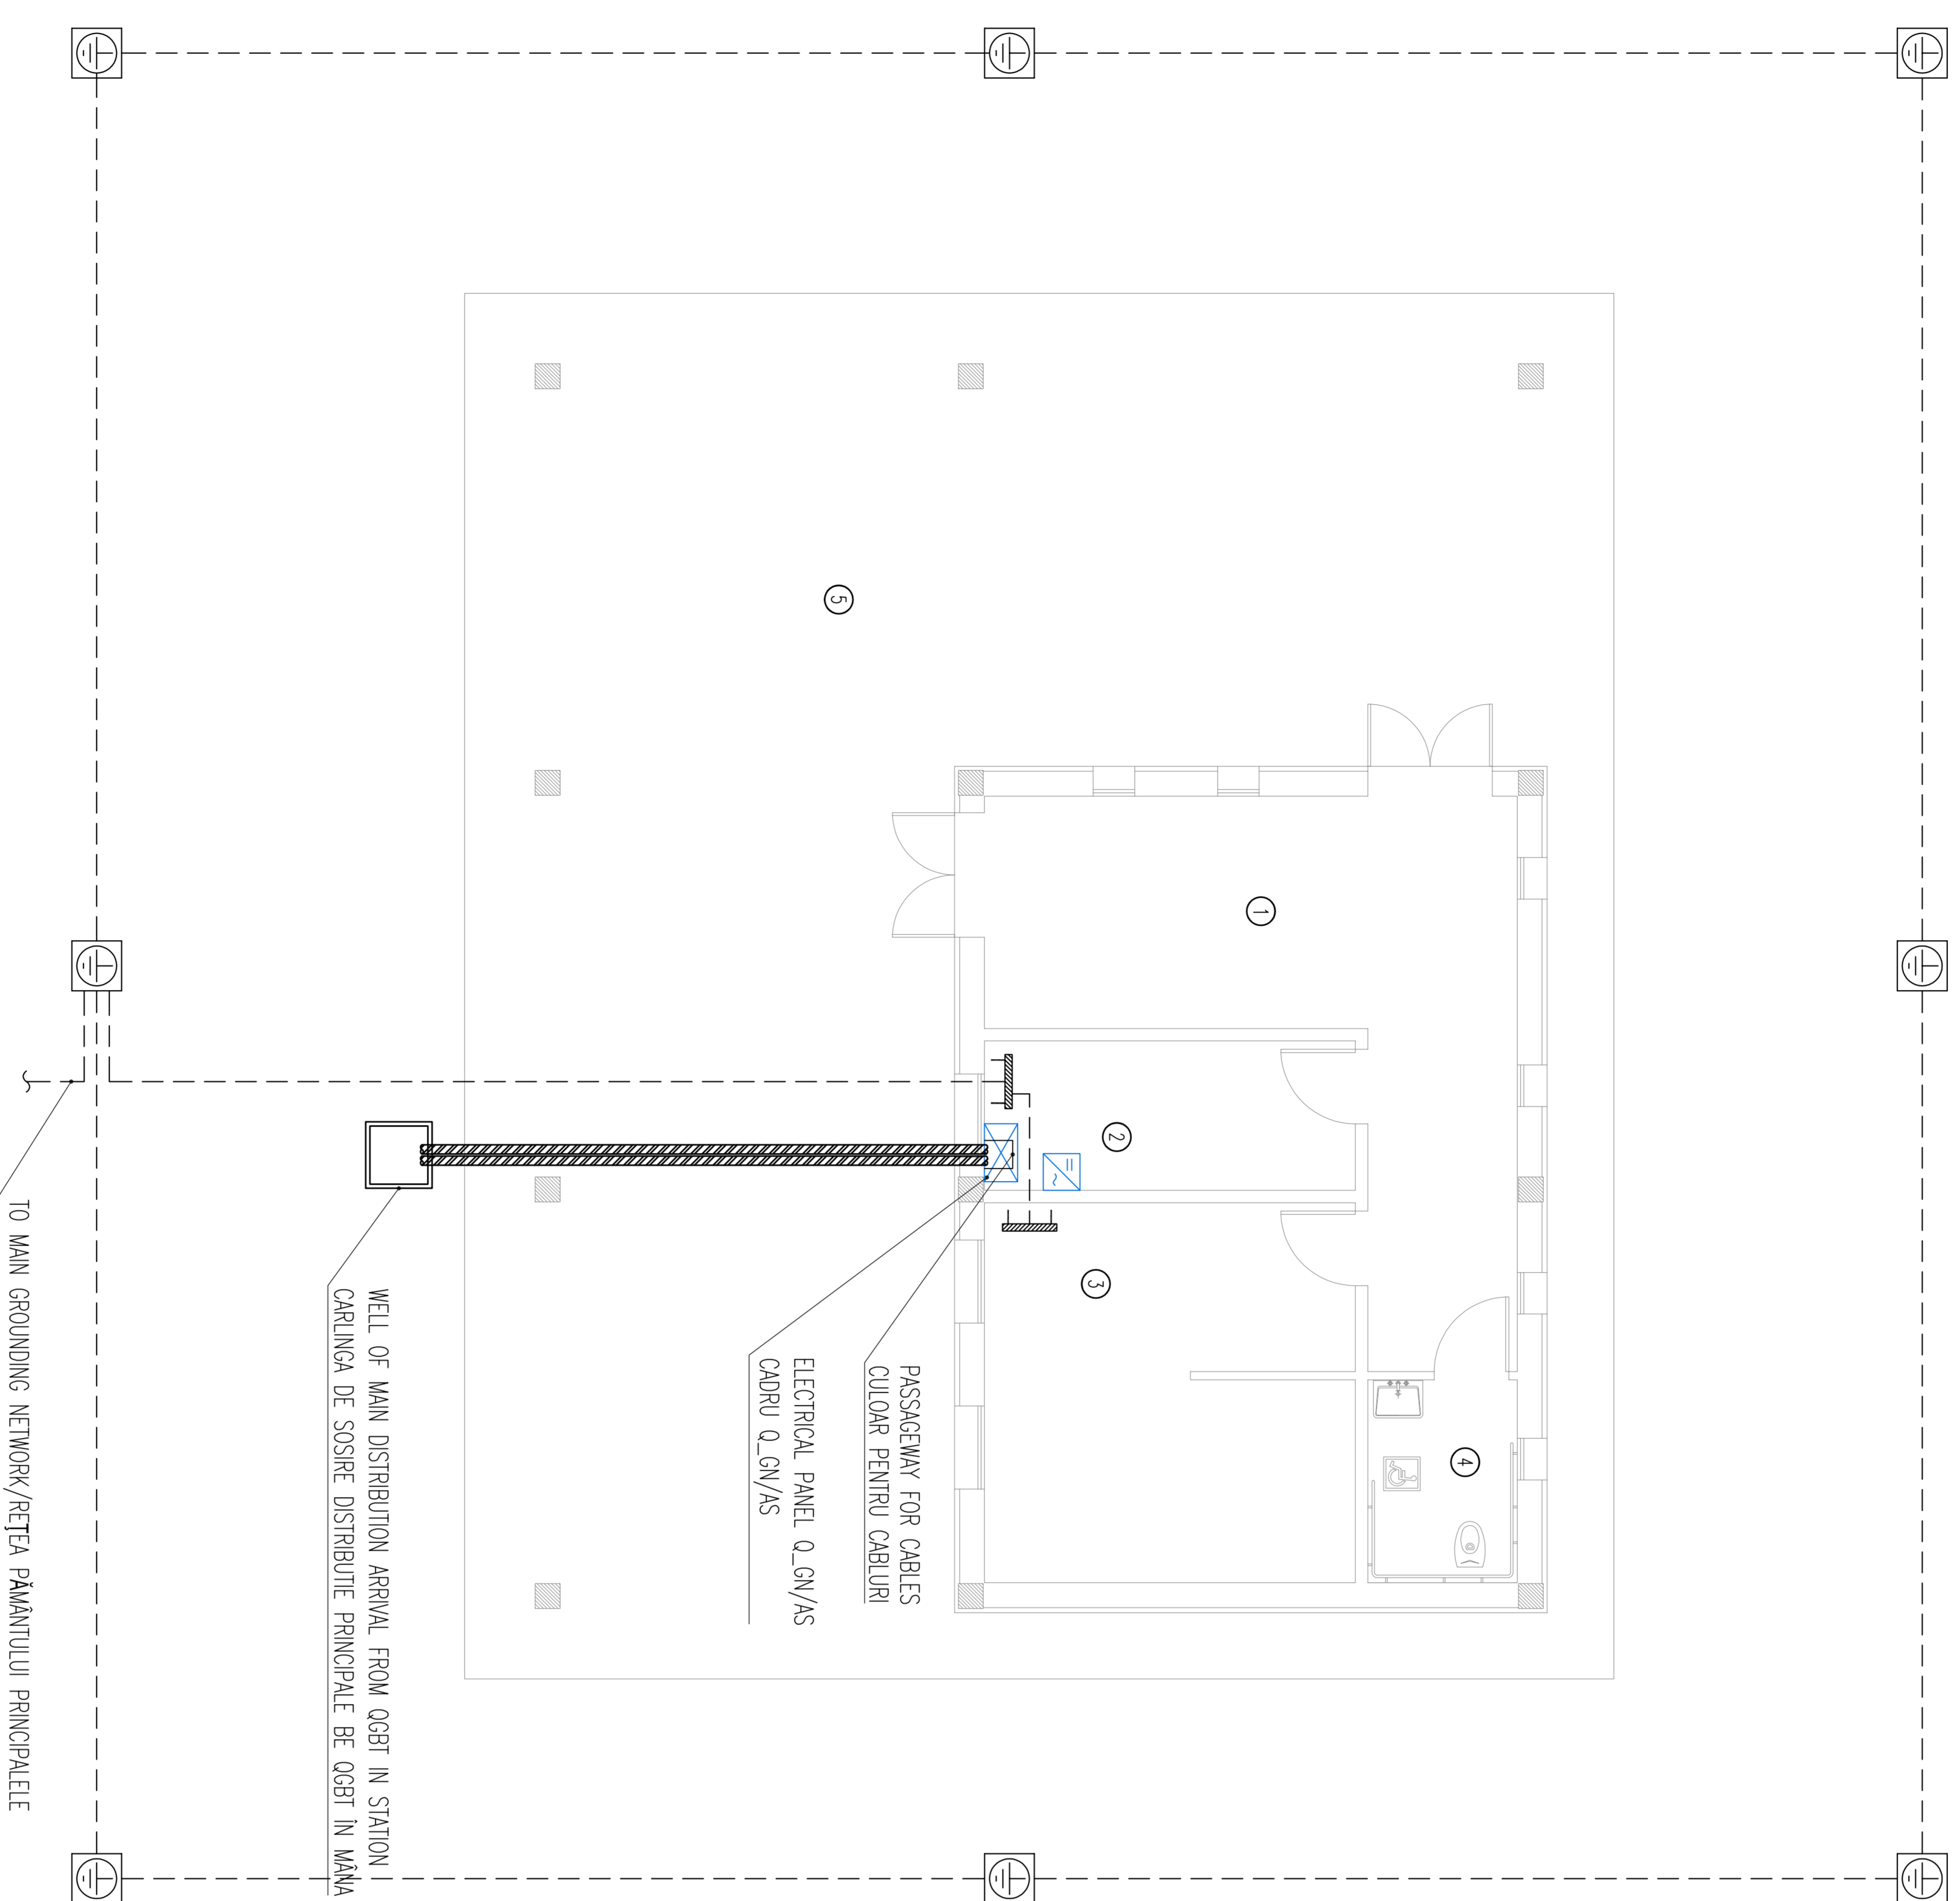

LOCAL	DESCRIPTION/DESCRIERE
1	WELLING LOCAL
2	LOCAL IN XESTRANE
3	CHIRURGIE
4	M.C.
5	M.C./PAMANT

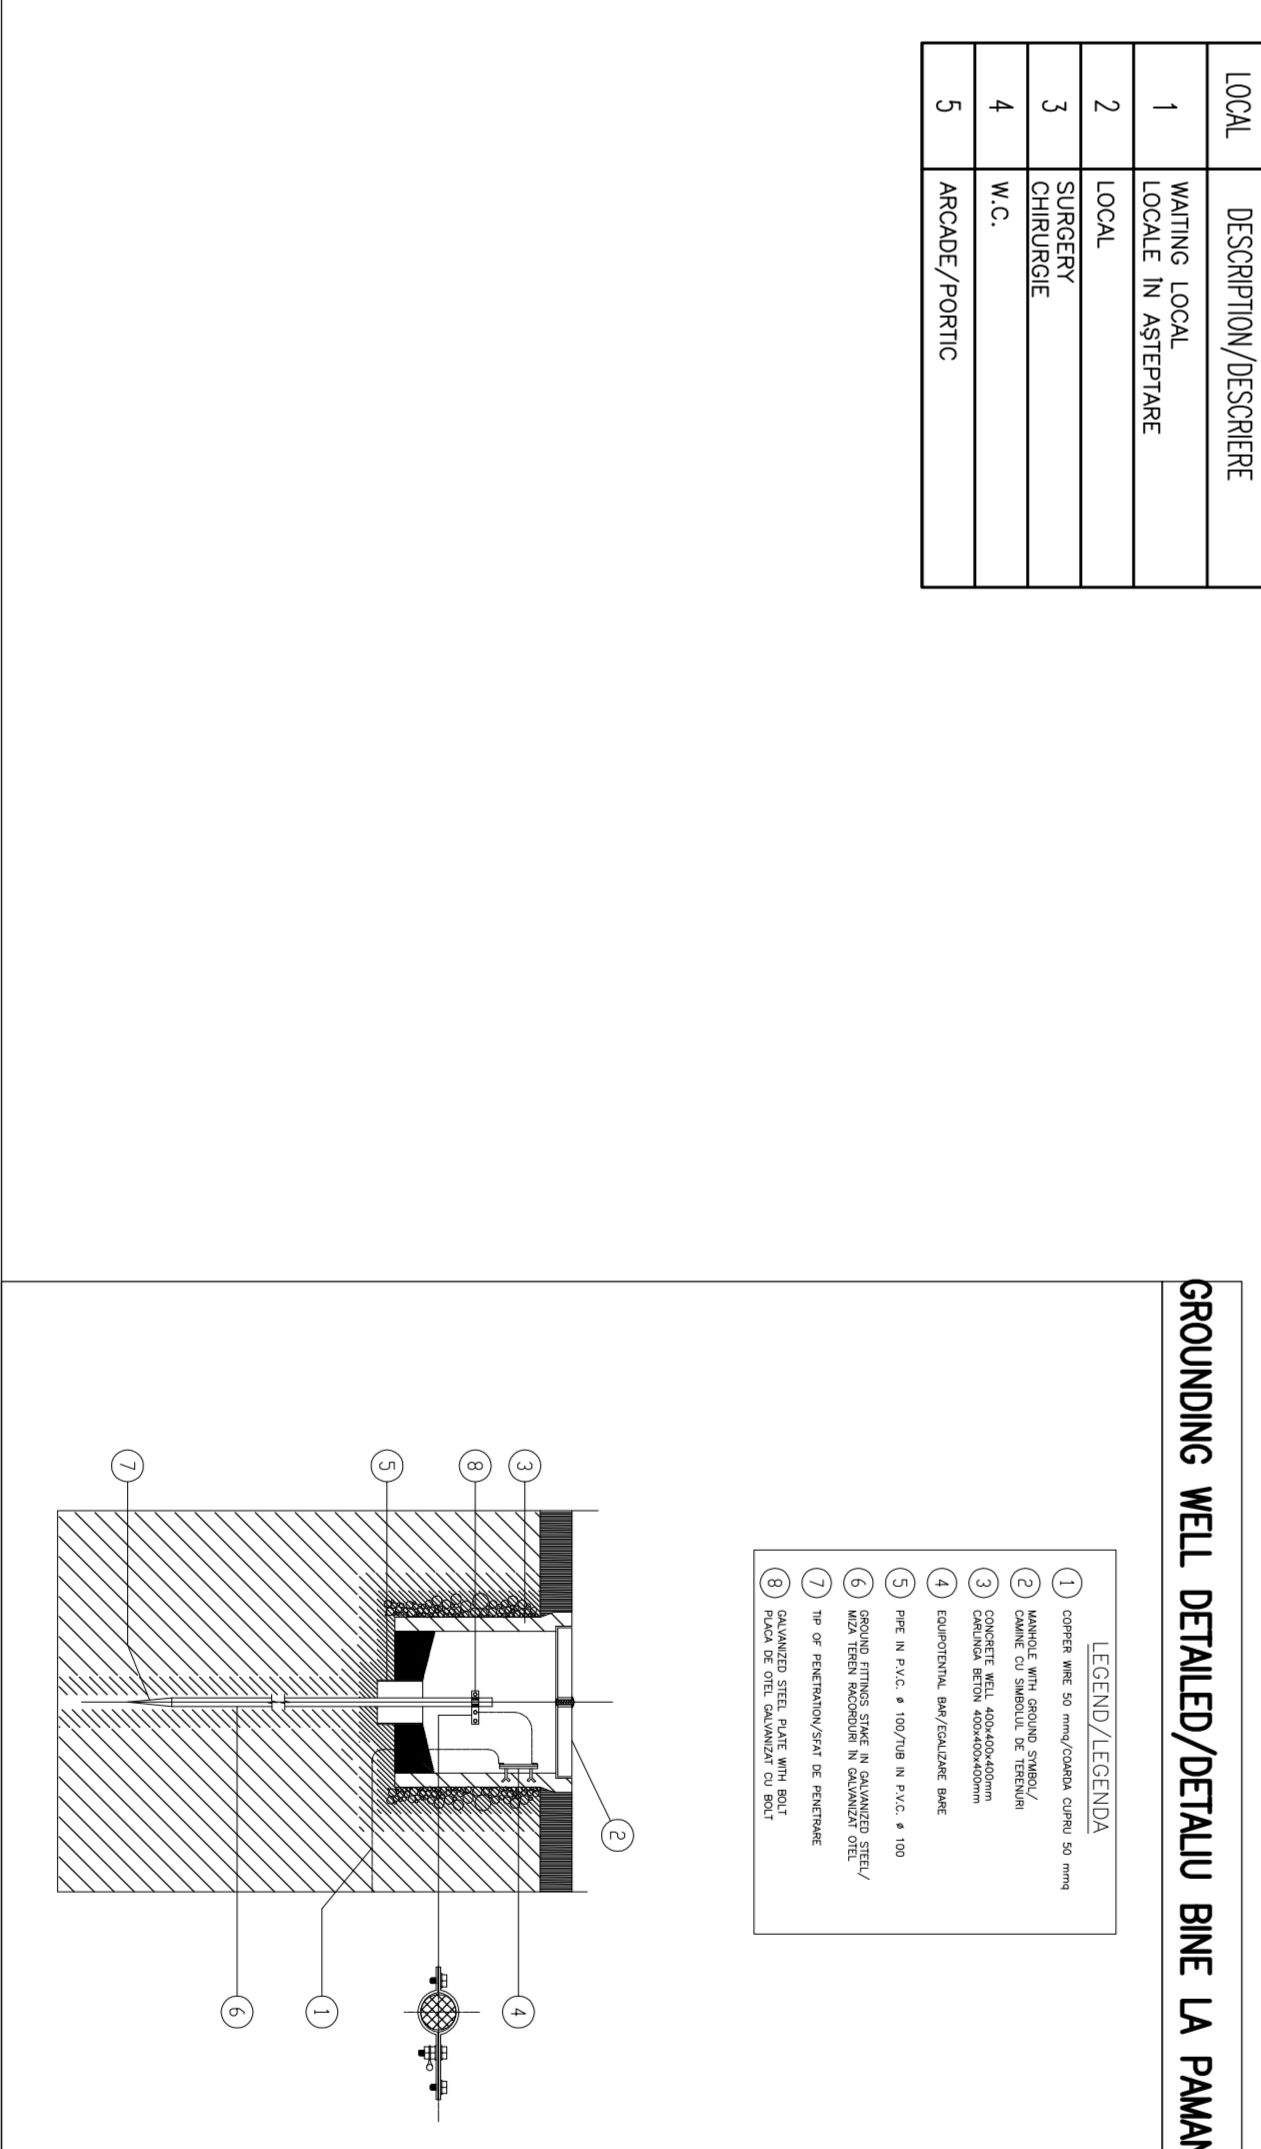

SYMBOLS LEGEND/LEGENDA SIMBOLOURI

SYMBOL/SIMBOLUL	DESCRIPTION/DESCRIERE
	ELECTRICAL PANEL/CADRU ELECTRICE
	WELL OF MAIN DISTRIBUTION ARRIVAL FROM OHL IN STATION CARLINGA DE SOSRE DISTRIBUIE PRINCIPALE DE OBL IN MAIN
	GROUND INSPECTION WELL 400x400x400 mm WITH SINK BNE LA PAMANT INSPECT 400x400x400 mm CU CHIURUGIA
	COPPER WIRE 50 mm <sup>2</sup> /CADRUL CUPRU 50 mm <sup>2</sup>
	COPPER BAND 4x20 mm/banda cupru 4x20 mm
	COPPER EQUIPMENT BAR/EQUIPARE CADRU BARE
	THREE PHASE METERS FOR NETWORK CONNECTION CONNECTION DC-AC/INVERTOR TRII FAZA PENTRU RETEA/CONECTIE DC-AC INVERTOR TRII FAZA

KEY MAP/HARTA CHEIE



D									
C									
B									
A									

**GOVERNUL ROMANIEI**  
**ROMANIA**  
**PROIECT PAMANT DE INGINERIA EUROPEANA**  
**EUROPEAN STANDARD PROJECT**

**CLIENT / CLIENT**  
**C.N.C.F. "C.F.R." - S.A.**

**CONSULTANT / CONSULTANT**  
**TECHNIC**

**APPROVED**  
**DATE**  
**SIGNATURE**

**REVISIONS**  
**NO.**

**CONDITII DE UTILIZARE**  
**Scale: 1:50**

**CONDITII DE UTILIZARE**  
**Scale: 1:50**

**CONDITII DE UTILIZARE**  
**Scale: 1:50**