

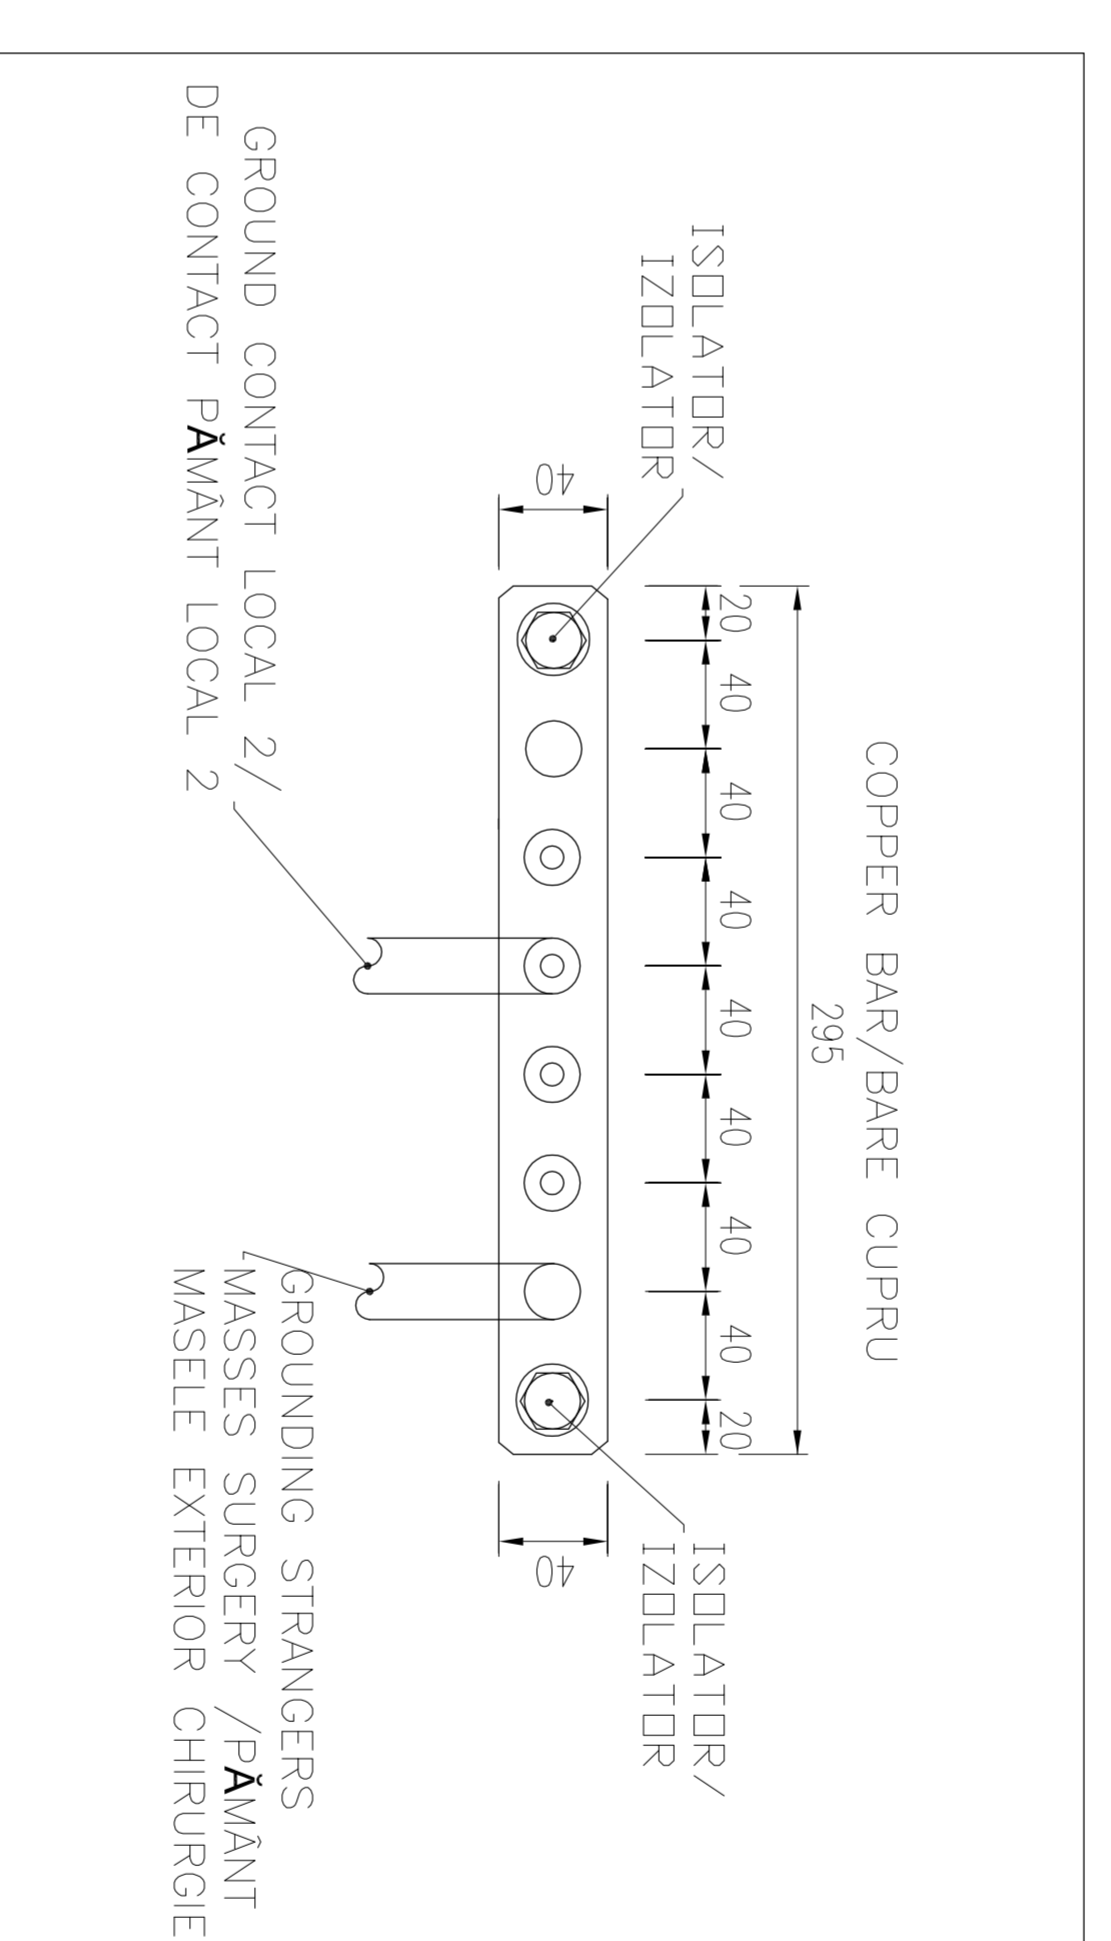
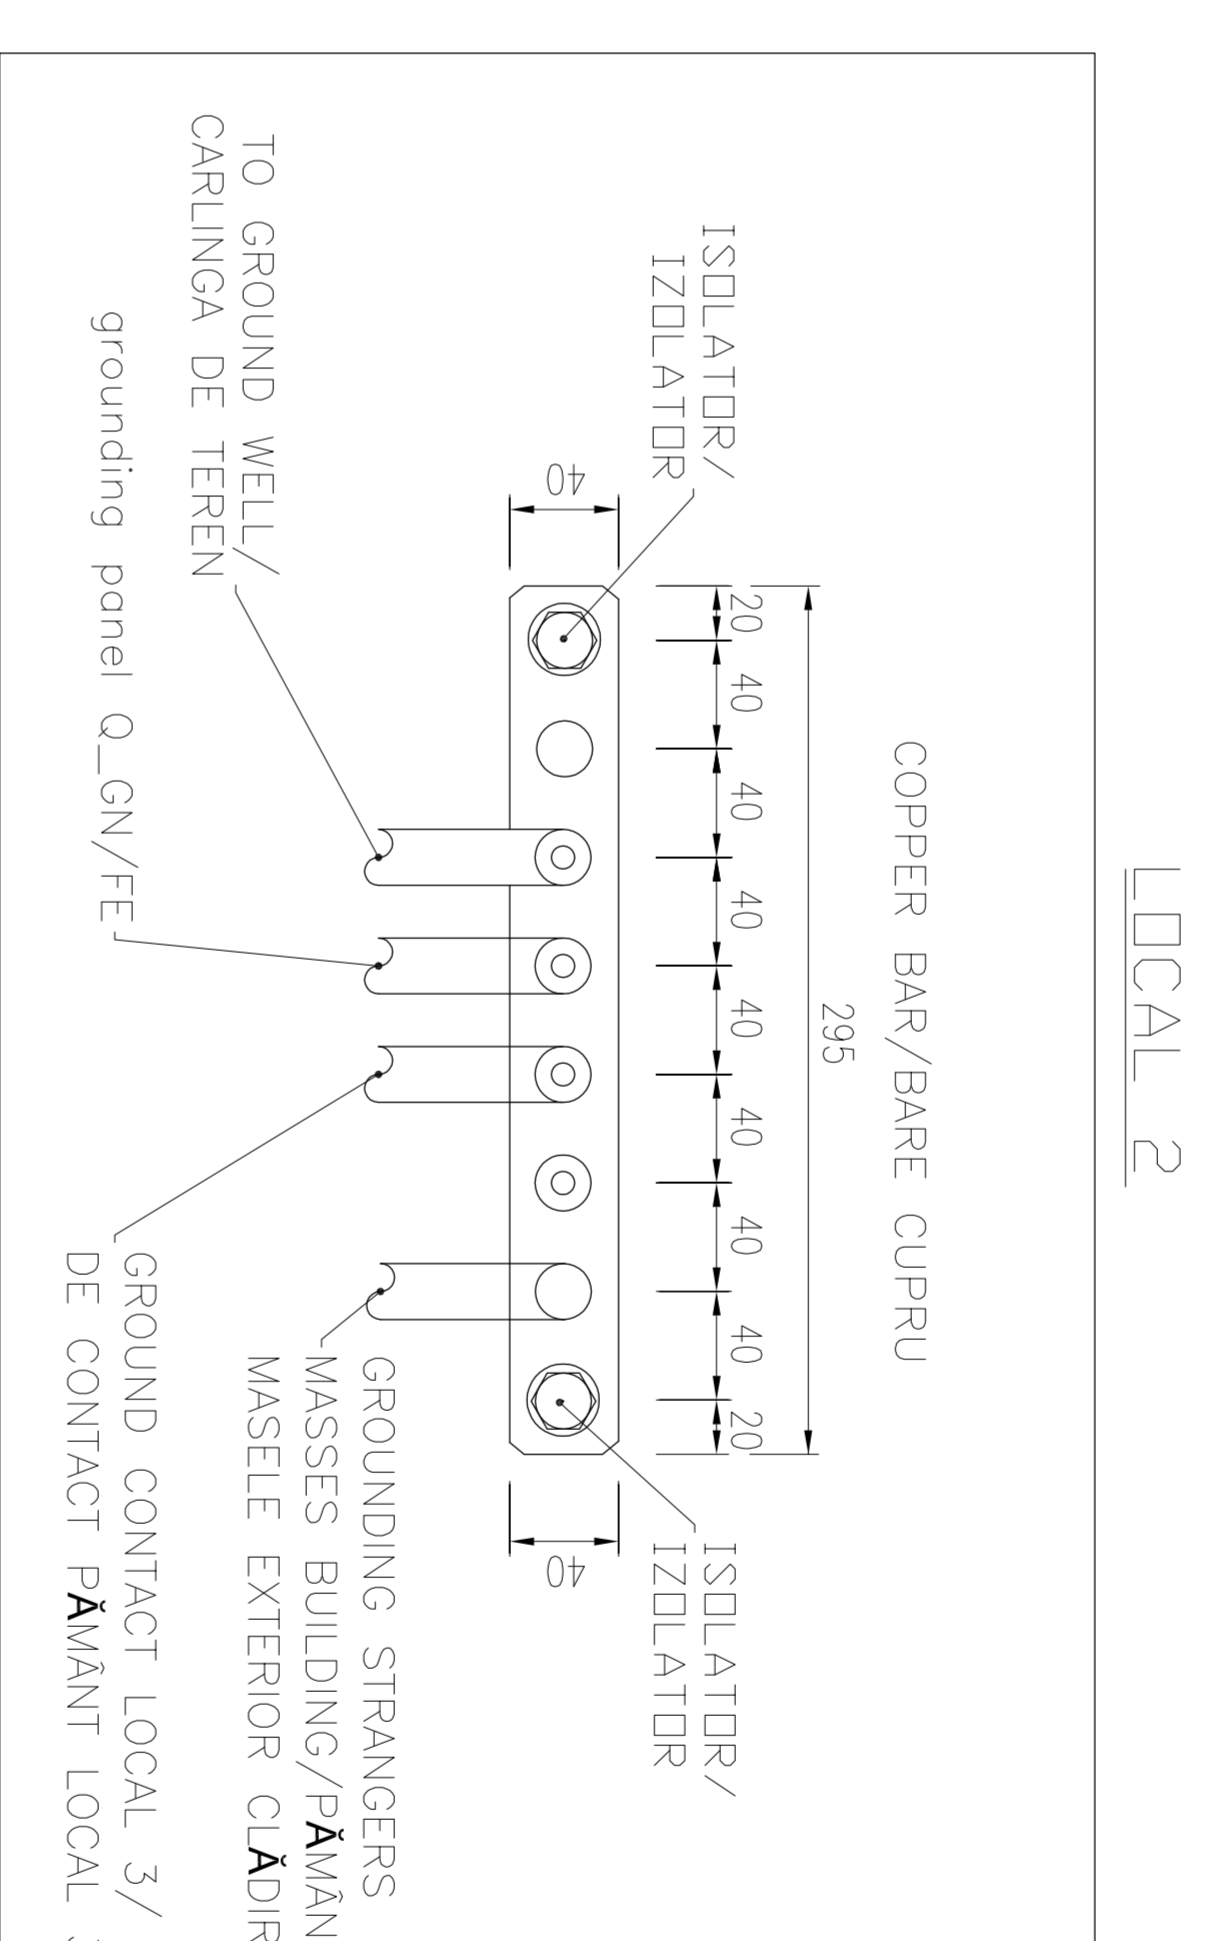


MEDICAL CARE BUILDING GROUND FLOOR PLAN/CLADIRE DE SANATATE PLAN DE PARTER – SCALE 1:50

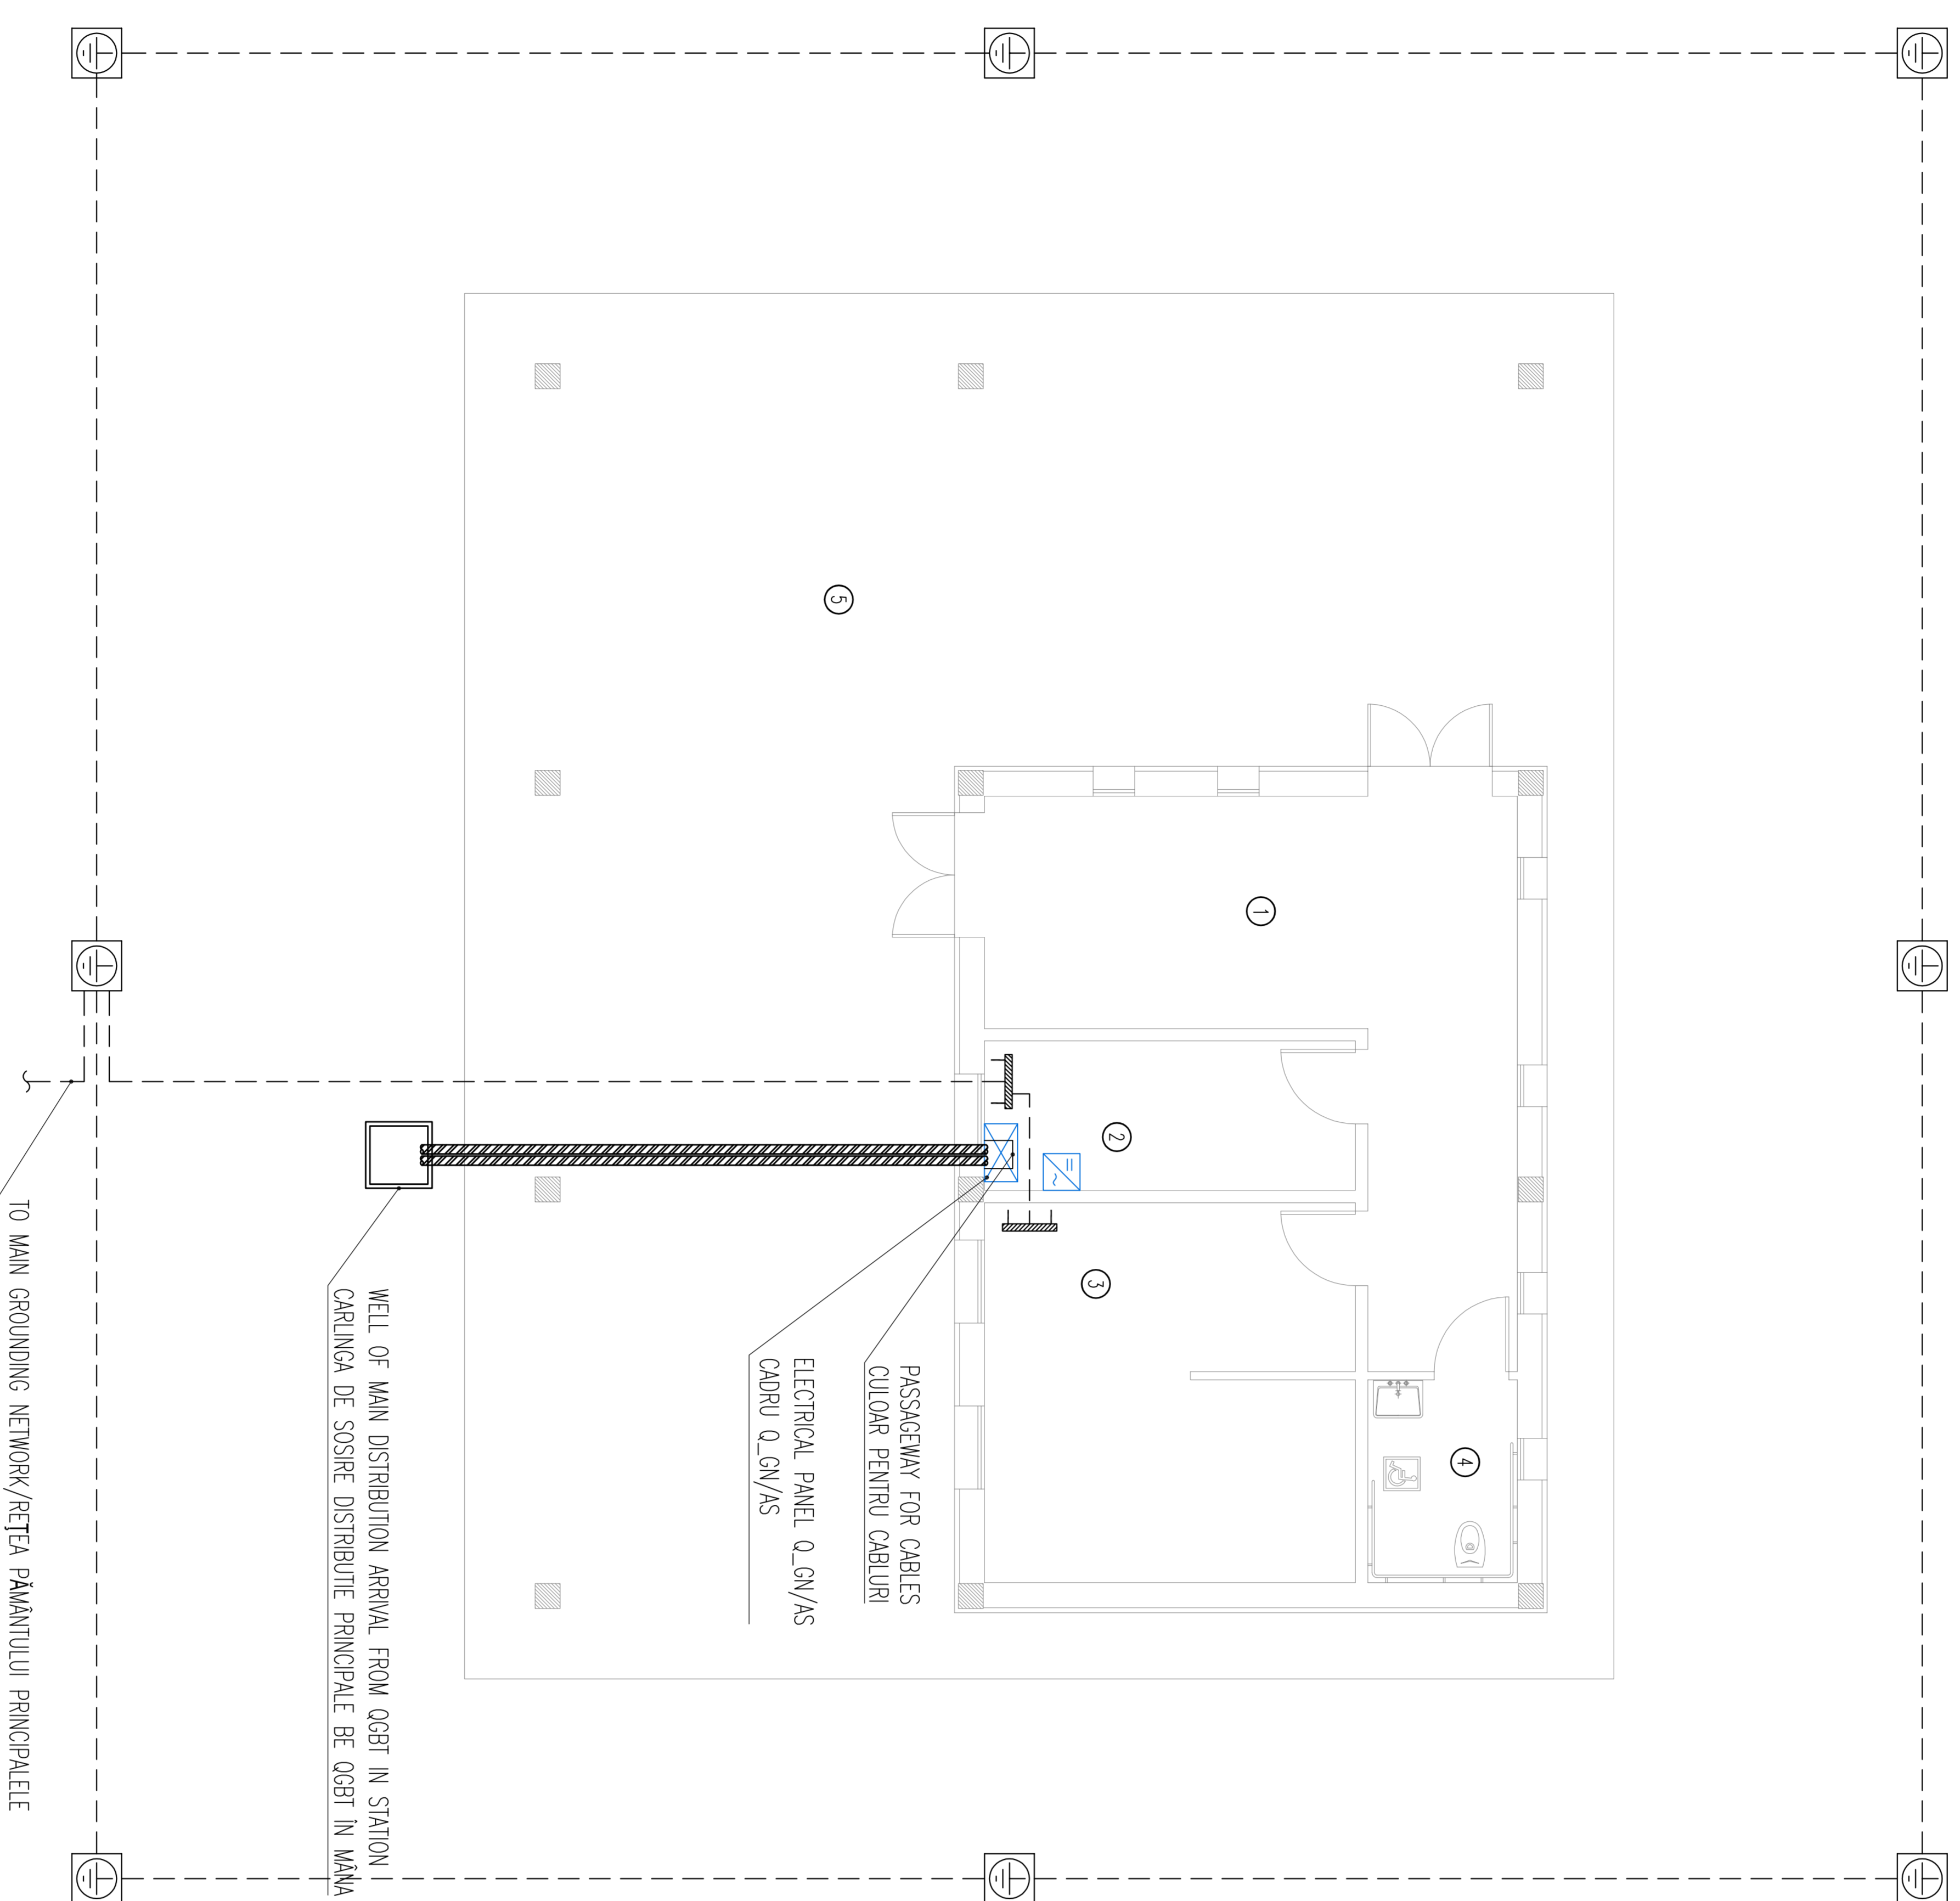


LOCAL	DESCRIPTION/DESCRIERE
1	WELLING LOCAL
2	LOCAL IN XESTRANE
3	GROUNDING STRANGERS
4	GROUNDING STRANGERS
5	WELLING/POZ

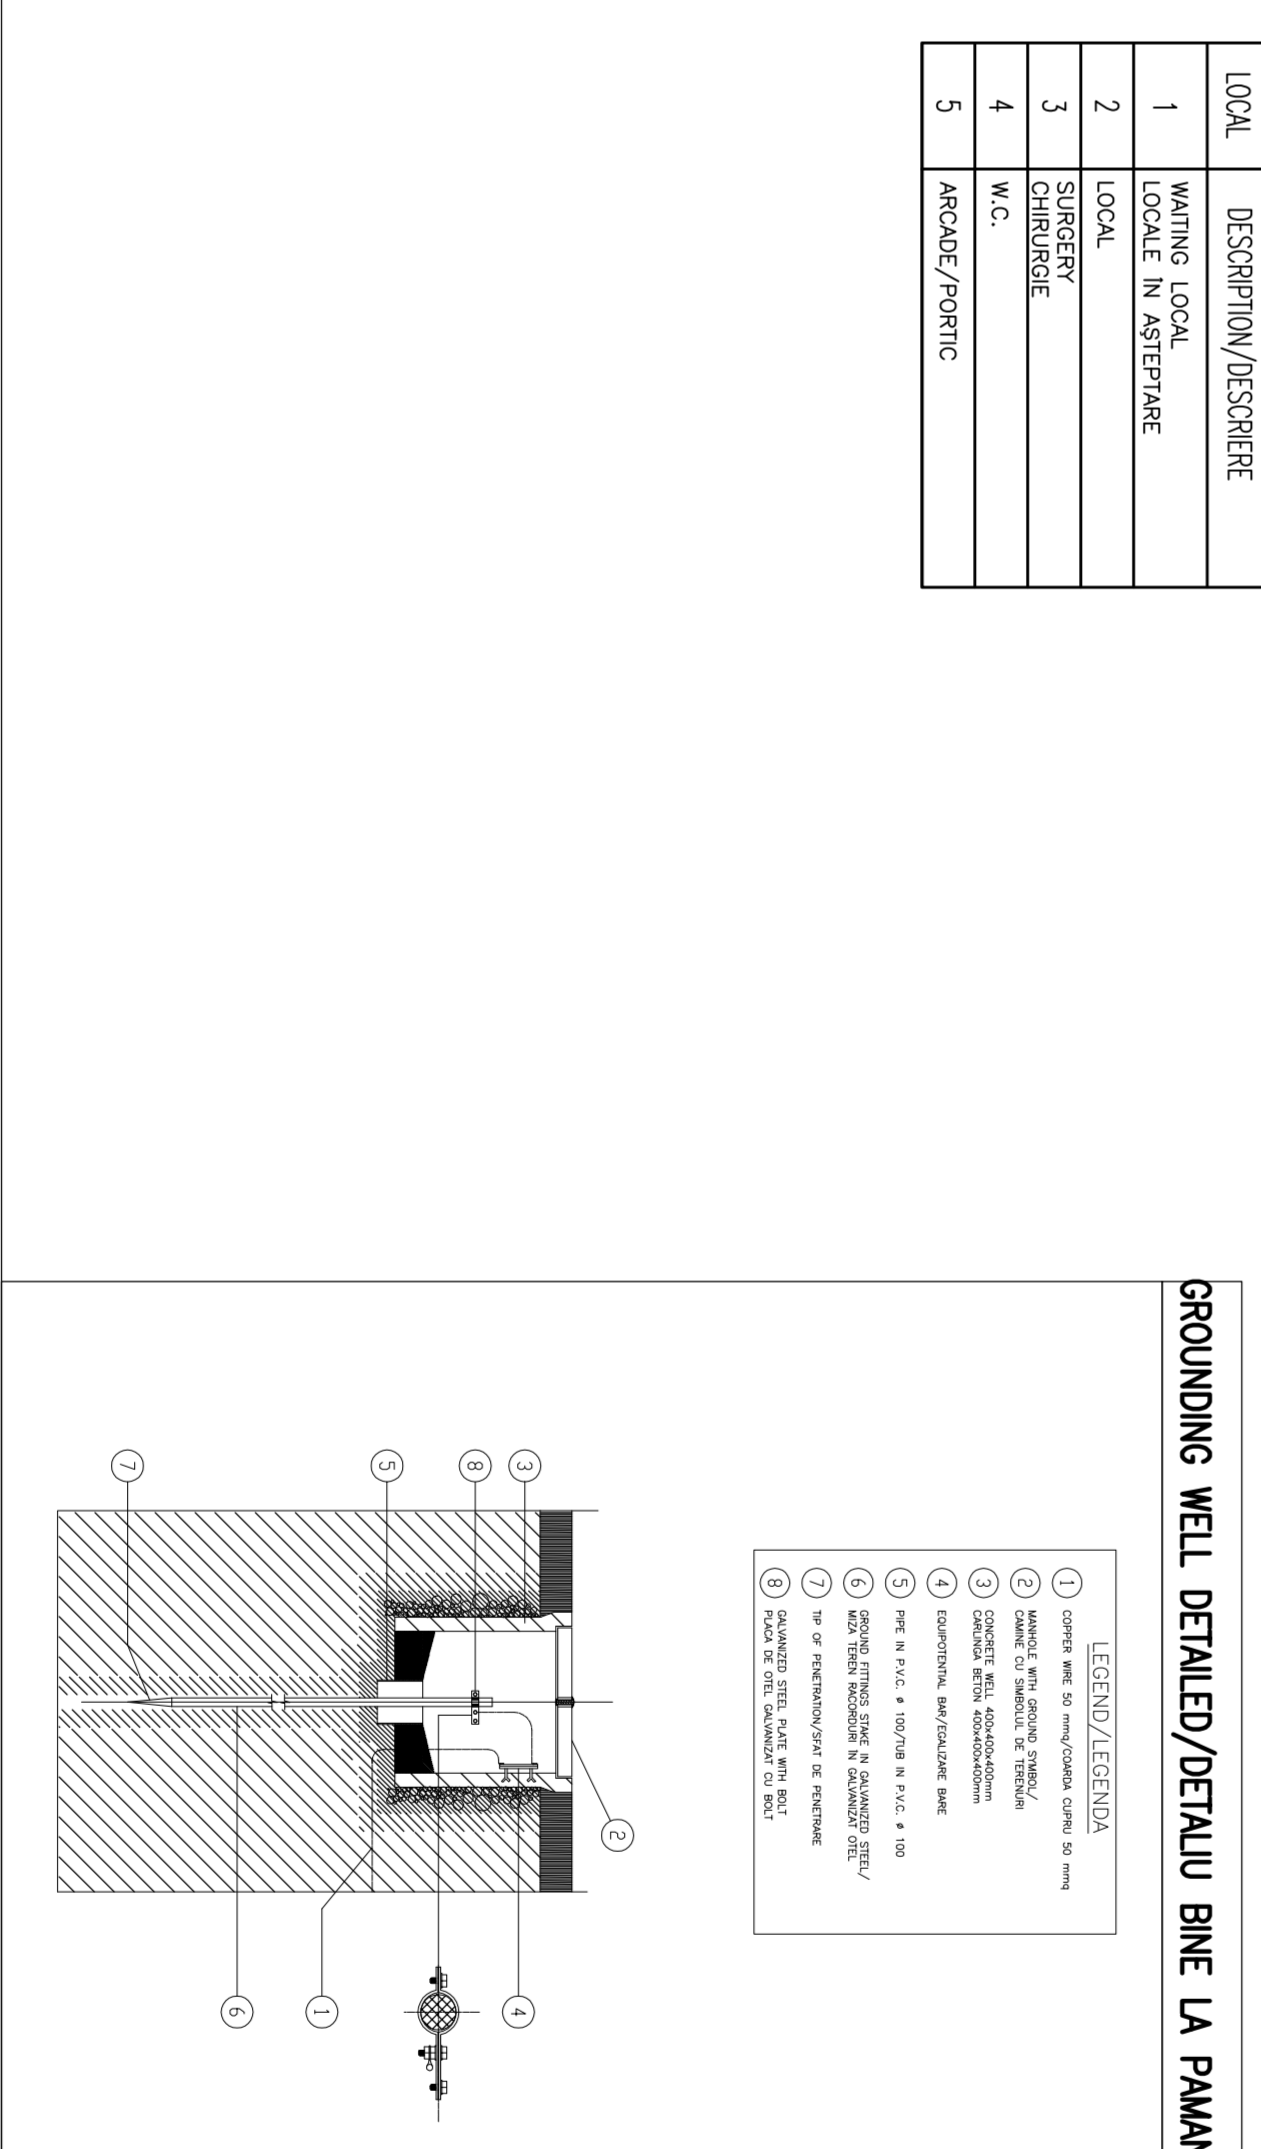

SYMBOLS LEGEND/LEGENDA SIMBOLOURI

SYMBOL/SIMBOLUL	DESCRIPTION/DESCRIERE
	ELECTRICAL PANEL/COBLU ELECTRICE
	WELL OF MAIN DISTRIBUTION ARRIVAL FROM COBT IN STATION CARLINGA DE SOSRE DISTRIBUIE PRINCIPALE DE COBT IN MAIN
	GROUNDING STRANGERS MASELE EXTERIOR /PAMANT DE CONTACT LOCAL 3/
	GROUNDING STRANGERS MASELE EXTERIOR /PAMANT DE CONTACT LOCAL 2/
	COPPER BAR/BARE CUPRU 25 mm
	COPPER BAR/BARE CUPRU 40x20 mm
	COPPER BAR/BARE CUPRU 40x30 mm
	THREE PHASE WASTER FOR NETWORK CONNECTION, CONNECTION DC-AC/INVERTOR TRIU FAZA PENTRU RETE/CONECTIE DC-AC INVERTOR TRIU FAZA

KEY MAP/HARTA CHEIE

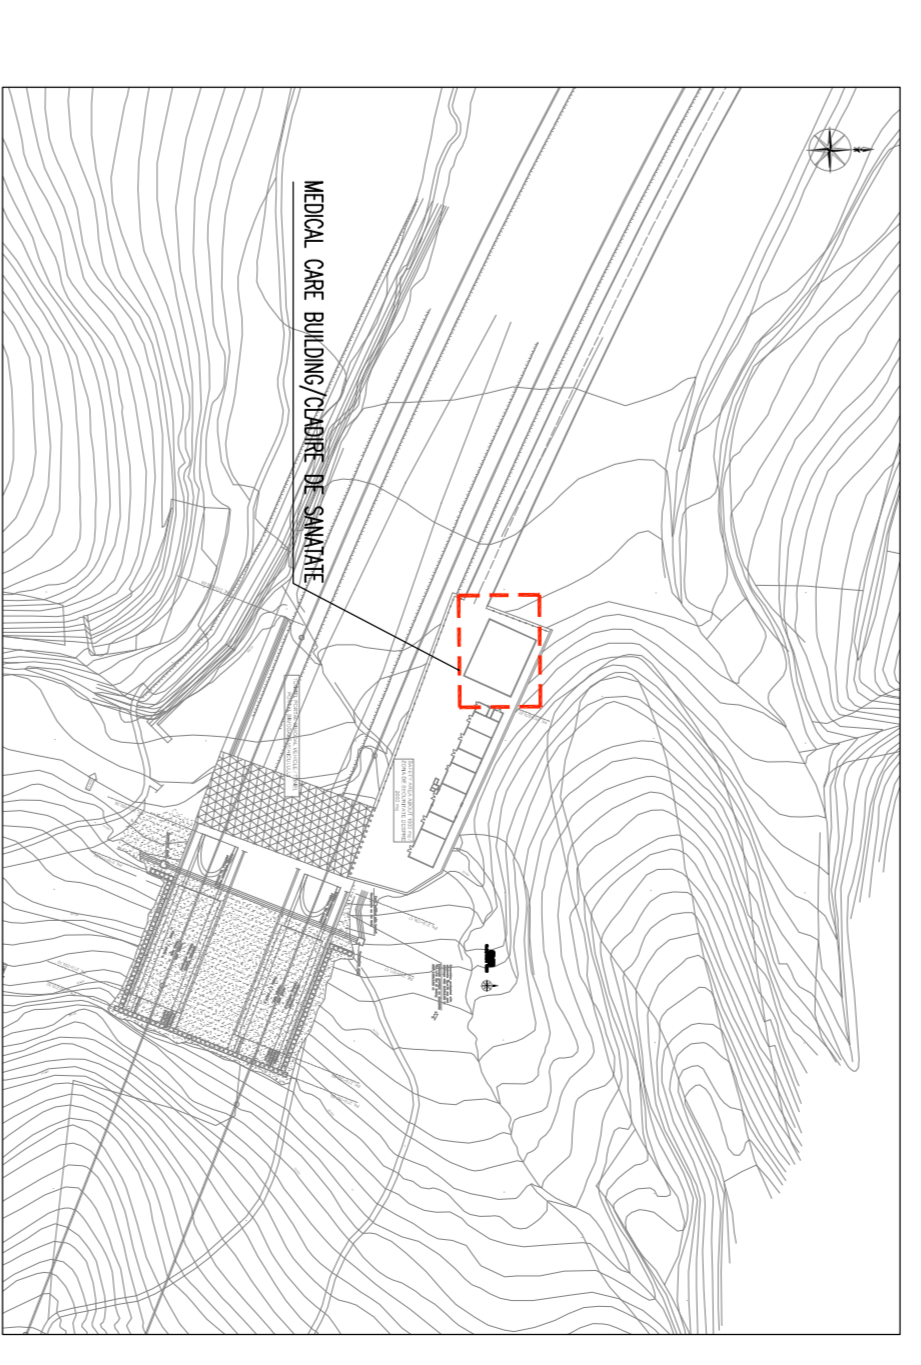

CLIENT / CLIENT	C.N.C.F. "C.F.R." - S.A.
CONSULTANT / CONSULTANT	TECNIC CONSULTING
PROJECT MANAGER / MANAGER	R. LUZZA
APPROVED / APROBAT	C. GEMINELLI
DESIGNED / PROIECTAT	C. GEMINELLI
DATE / DATA	P. ANTONIO

PROIECT/PROIECTAT	PROIECTAT
DATE / DATA	P. 21.11.2023
PROIECTANT / PROIECTANT	P. ANTONIO
APPROBAT / APROBAT	C. GEMINELLI
DESIGNER / PROIECTANT	C. GEMINELLI
APPROVED / APROBAT	C. GEMINELLI
DATE / DATA	P. ANTONIO

CONDICȚII / CONDITIONS	Scale: 1:50
DATE / DATA	2023.11.21
PROIECTANT / PROIECTANT	P. ANTONIO
APPROBAT / APROBAT	C. GEMINELLI
DESIGNER / PROIECTANT	C. GEMINELLI
APPROVED / APROBAT	C. GEMINELLI
DATE / DATA	P. ANTONIO