

MEDICAL CARE BUILDING GROUND FLOOR PLAN/CLADIRE DE SANATATE PLAN DE PARTIER – SCALE 1:100

LOCAL	DESCRIPTIV/DESCRIERE
1	WANTING LOCAL
2	LOCAL ACOPERIRE
3	SUBSERVIER
4	W.C.
5	Medical/clinic


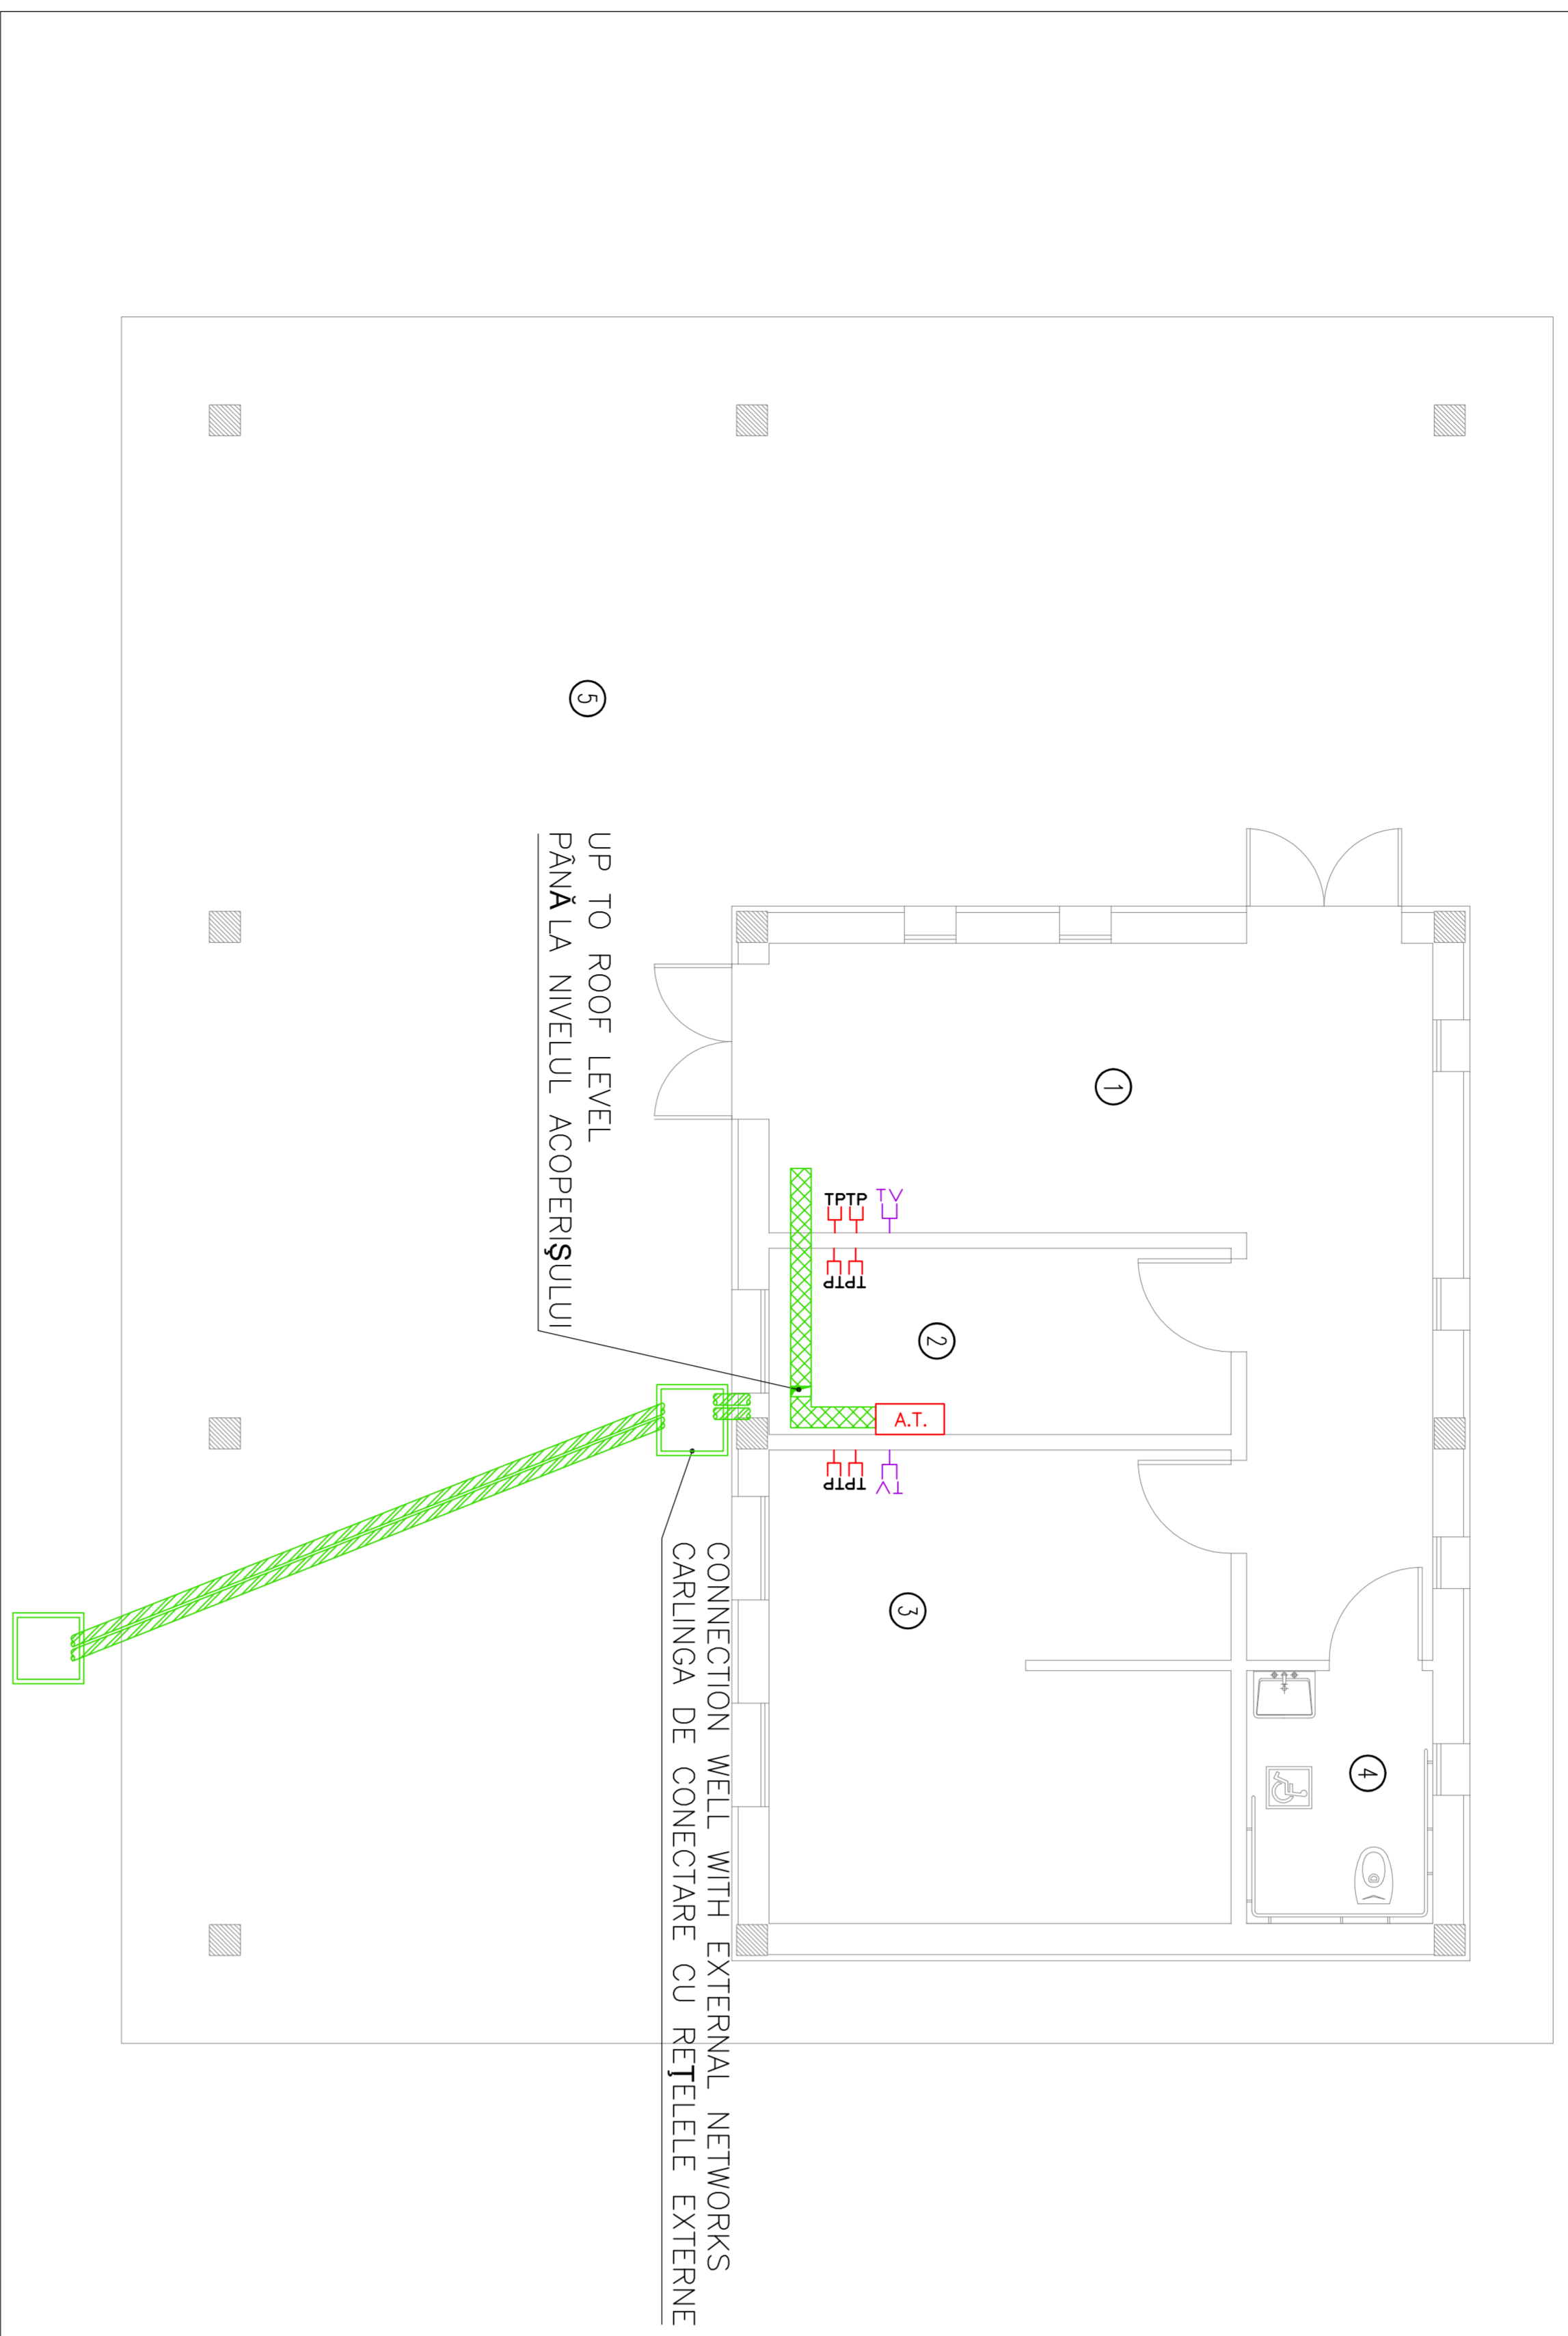


DIAGRAM TV SYSTEM/DIAGRAME SISTEMUL DE TV

CABLE FOR TRANSMISSION OF ANALOG AND DIGITAL TV SIGNALS/
CABLU DE TRANSMISIE A SEMNALULUI TV ANALOGIC SI DIGITAL

GROUND FLOOR/PLAN DE PARTIER

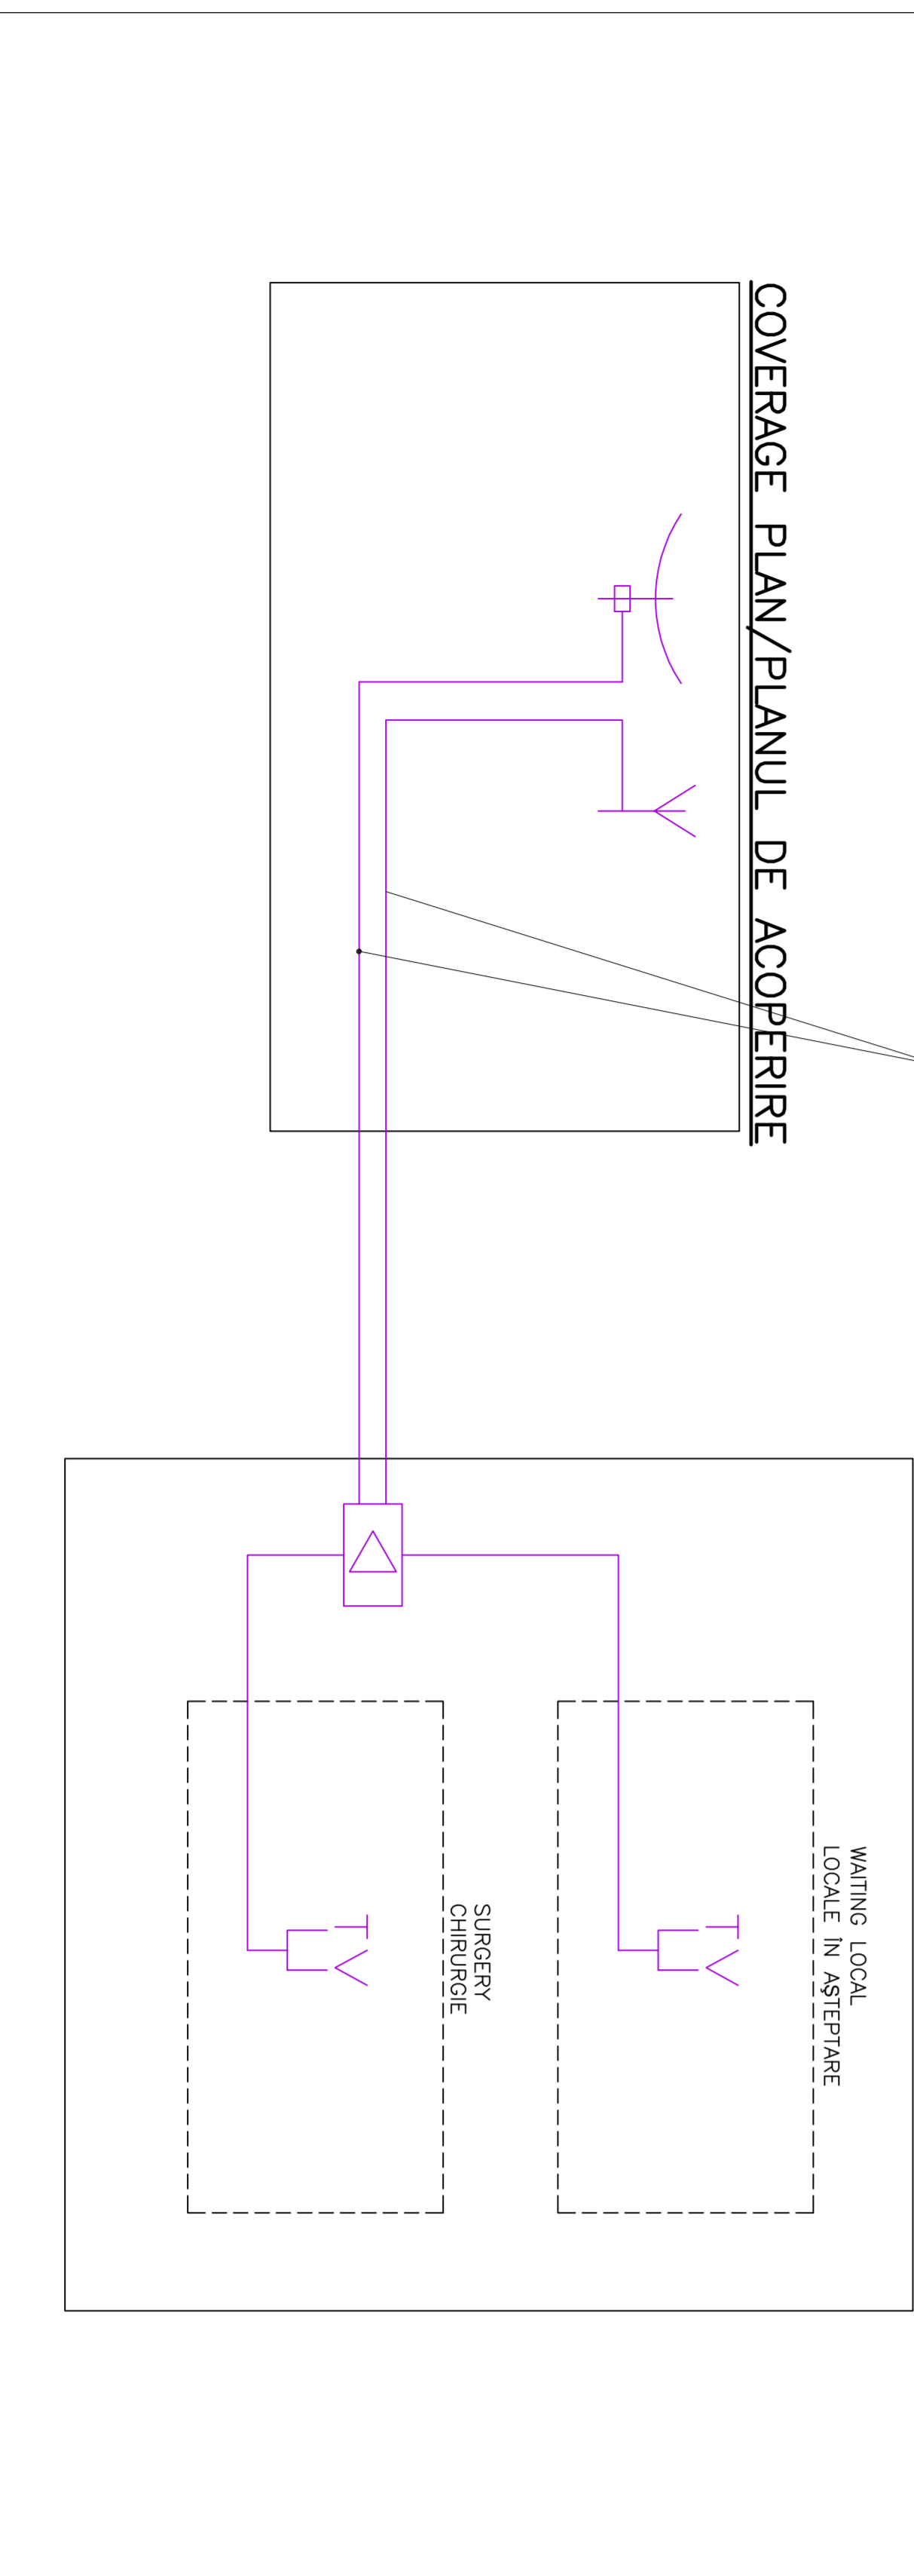

MEDICAL CARE BUILDING COVERAGE PLAN /CLADIRE DE SANATATE PLANUL DE ACOPERIRE – SCALE 1:50


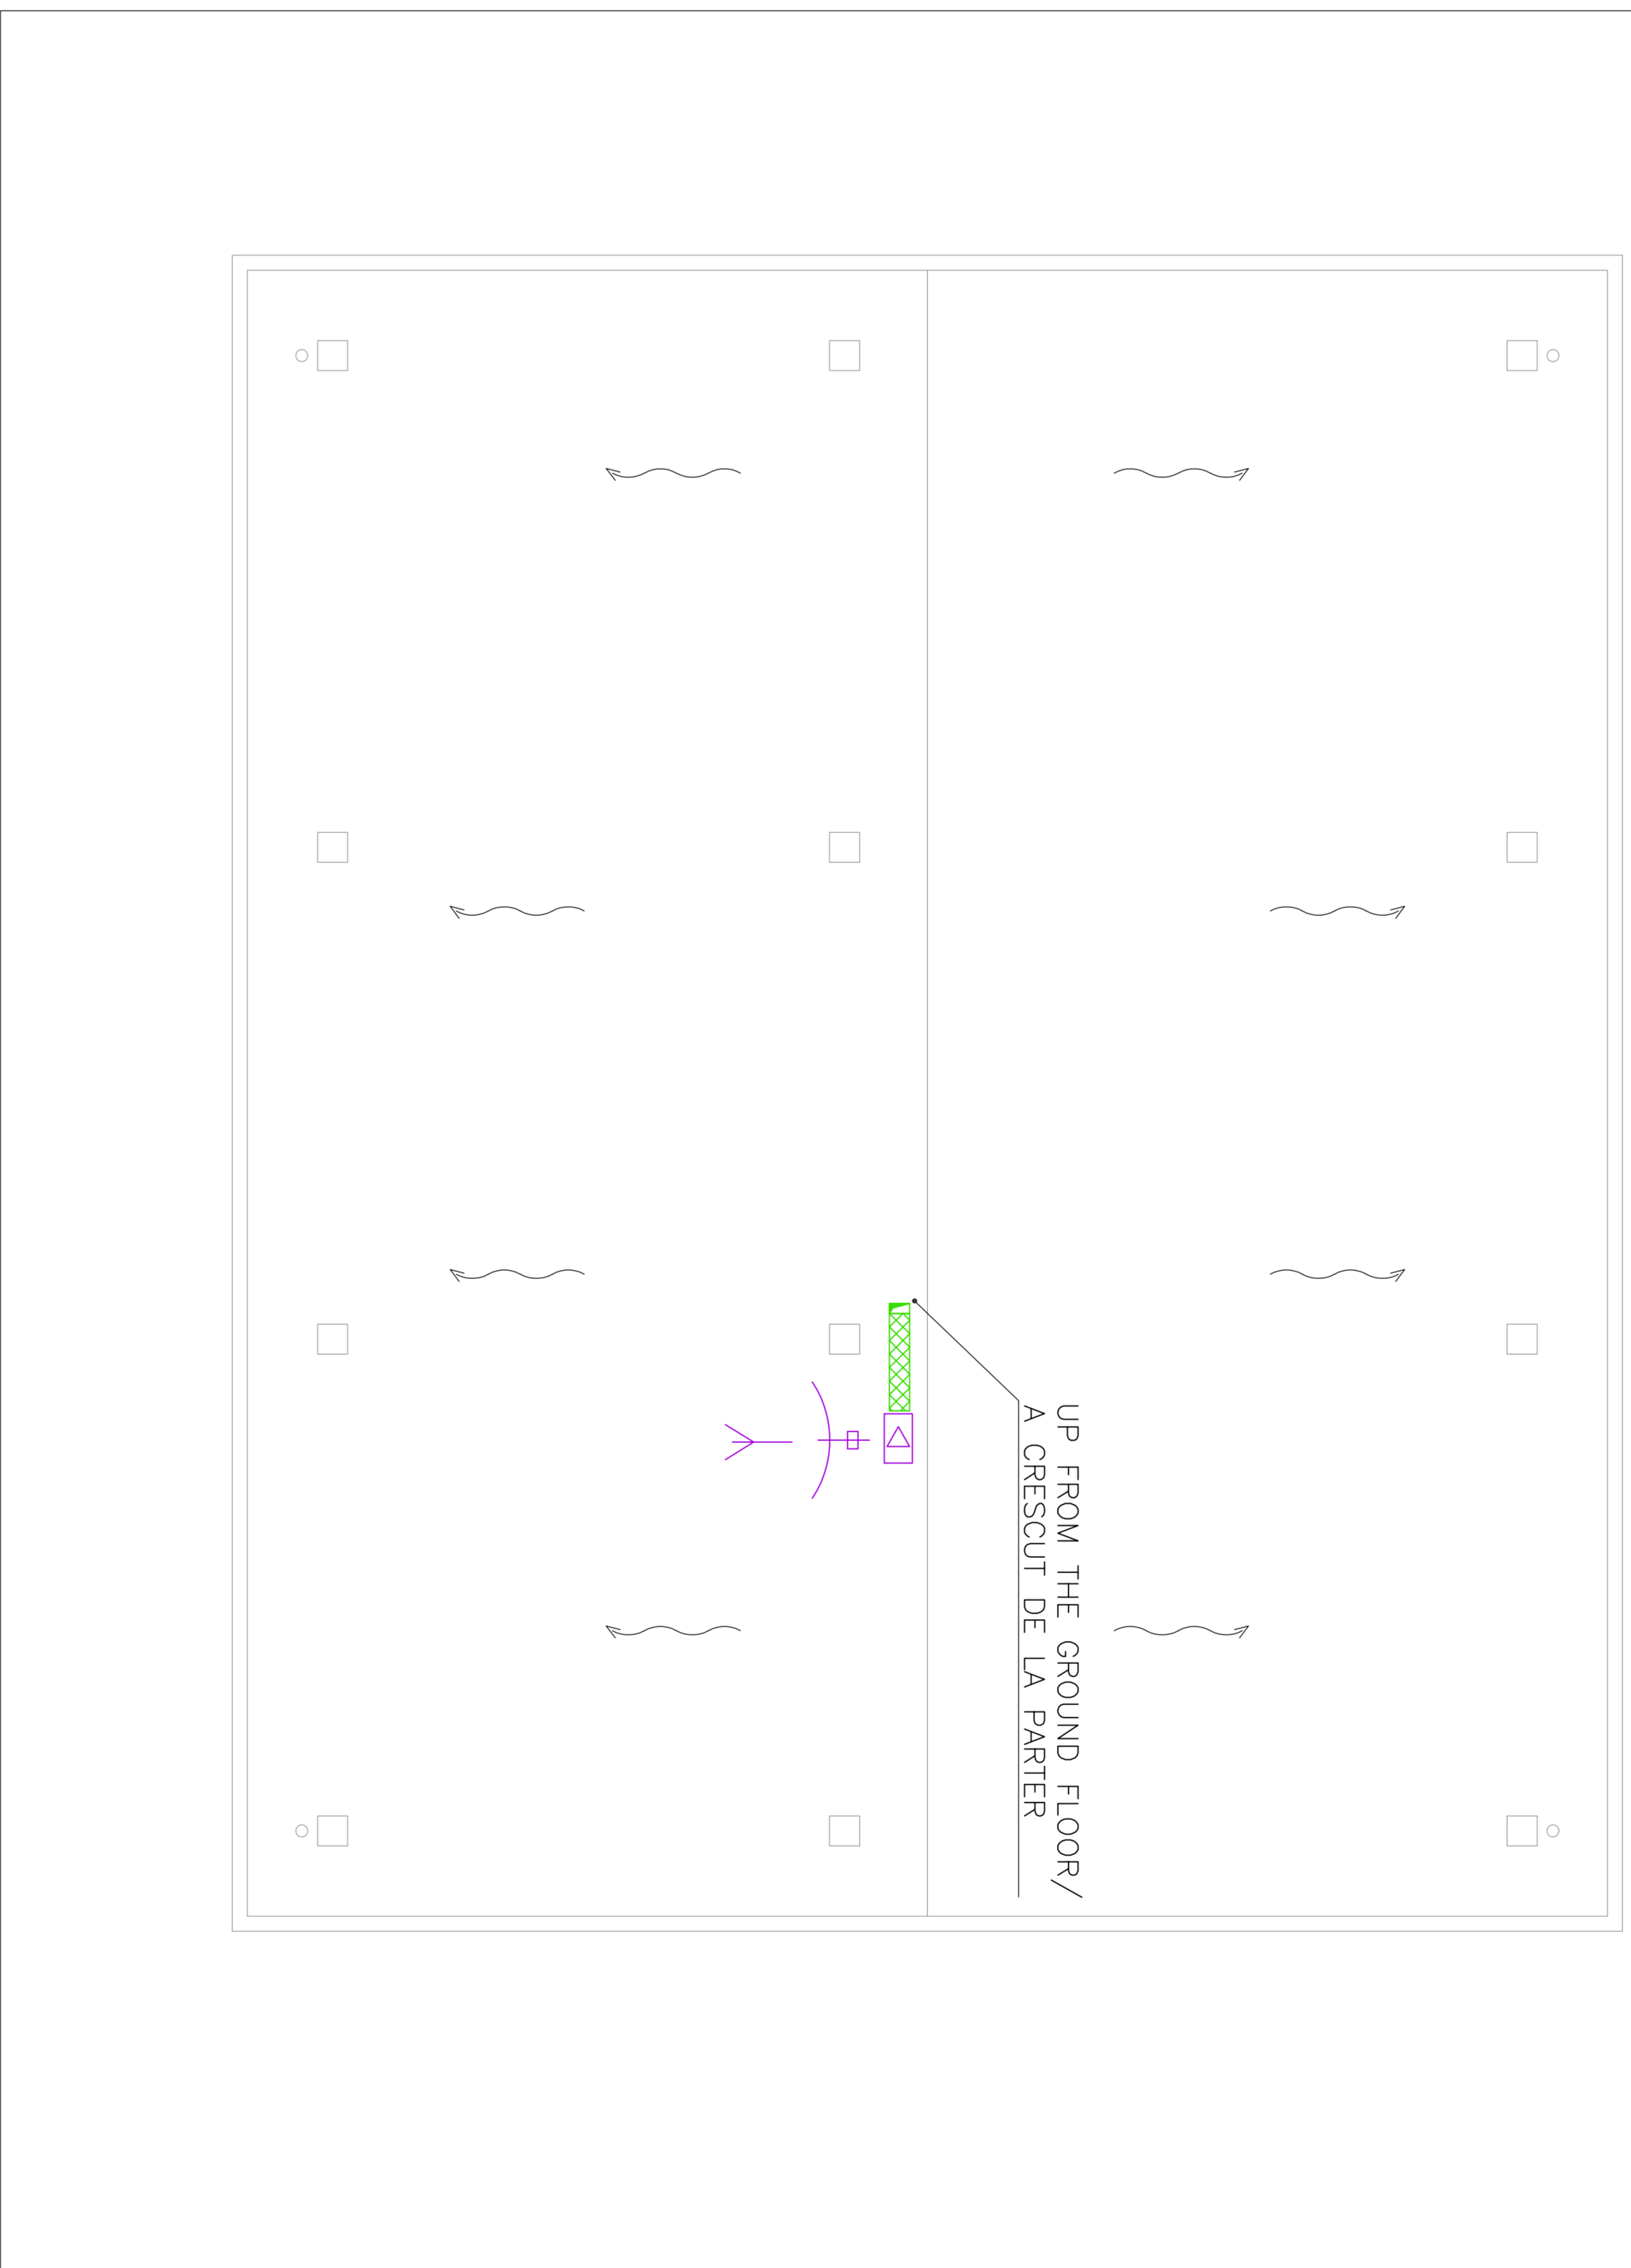


DIAGRAM VOICE-DATA SYSTEM/DIAGRAME SISTEMUL DE VOCE-DATA


GROUND FLOOR/PLAN DE PARTIER

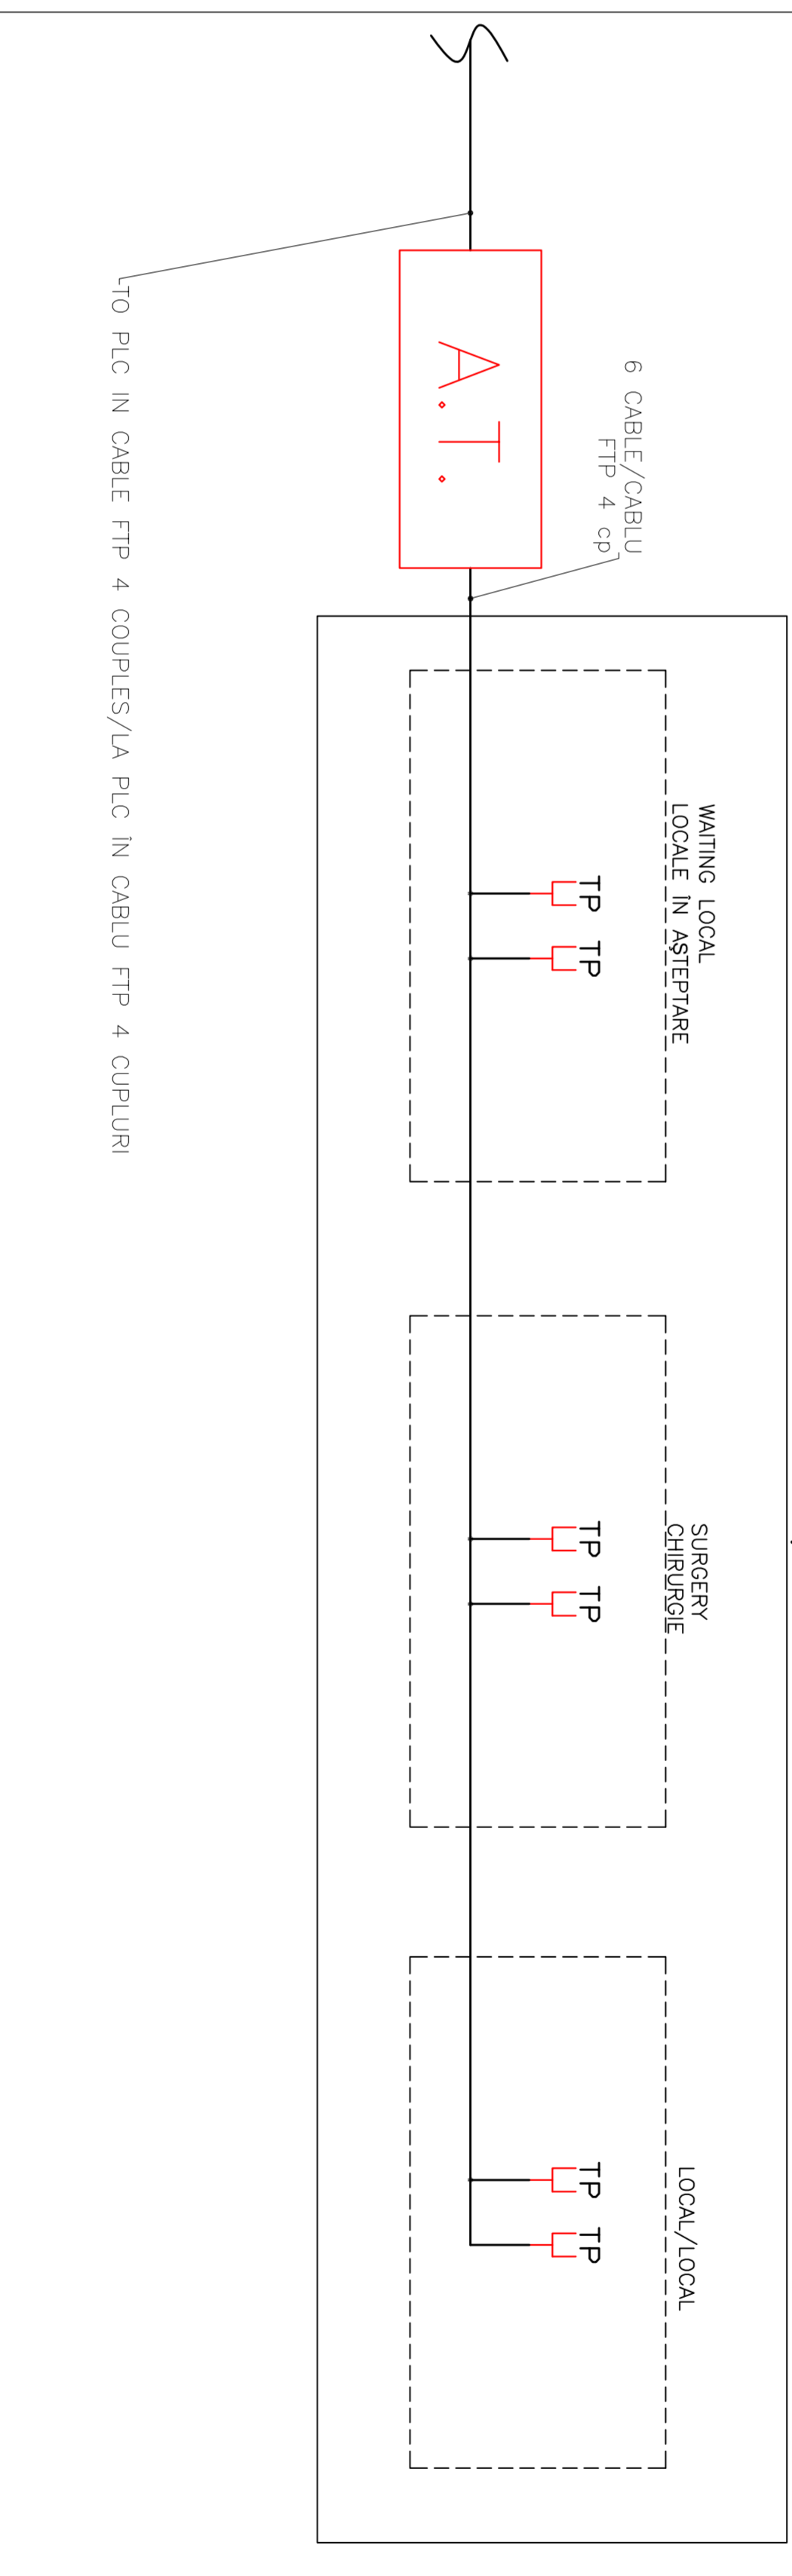

SYMBOL LEGEND/LEGENDA SIMBOLURI

SYMBOL/SIMBOLUL	DESCRIPȚIE/DESCRIERE
TP	VOICE-DATA RJ45 SOCKET/PIAZA VOCE-DATA RJ45
⌋	TERRESTRIAL TV ANTENNA/TERESTRIU TV ANTENA
⌋	SATELLITE TV ANTENNA/TV-SATELIT ANTENA
⌋	SOCKET GROUP CONNECT FROM A SOCKET OF TV ANTENNA OF TYPE TERRESTRIAL TV AND A SOCKET ANTENNA SATELIT/CABLU DE PRIZE ESTE LIAȚ DE LA REȚA DE ANTENNA TV DE TIP TERESTRIU SI DE TIP TV SATELIT
A.T.	CABLET FOR VOICE-DATA STRUCTURED CABLE/CABLETUL VOCE-DATA RICHIZI CABLETE STRUCTURATA
⌋	SMOOTHENED ALUMINUM SYSTEM TV/RABOTUL DE DISTRIBUTIE DE AMPLIFICARE TV
⌋	CABLE PREPARED STEEL GALVANIZED 200X100 MM FOR SPECIAL SYSTEM DISTRIBUTION
⌋	CABLE PREPARED STEEL GALVANIZED 200X100 MM FOR TV DISTRIBUTION SYSTEM SPECIALLY FOR TV SATELLITE
⌋	POLYETHYLENE CONDENSATOR EXTERNAL TV PREP. Ø 118 mm
⌋	TECH. SHEET FOR THE TV SATELLITE SYSTEM Ø 118 mm

KEY MAP/HARTA CHEIE

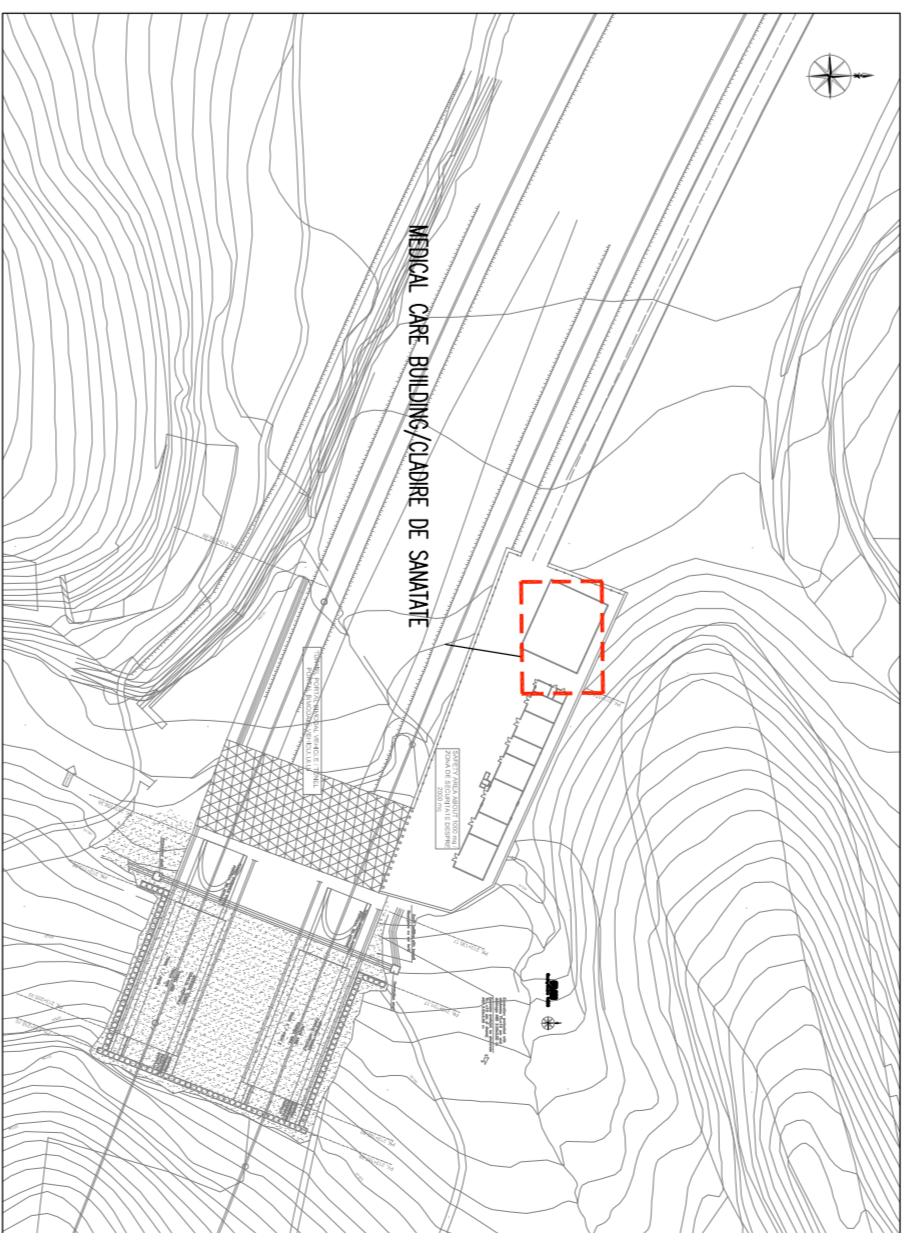

D				
C				
B				
A				

Date: _____
 Modificari/Modificari: _____
 Proiectant: _____
 Autorizati/Approbat: _____
 Date: _____

GOVERNUL ROMANIEI
 ROMANIAN GOVERNMENT
 PROIECT FINANȚAT DE UNIUNEA EUROPEANA
 ROMANIAN FINANCED PROJECT

C.N.C.F. "C.F.R." - S.A.

CLIENT / CLIENT			
CONSULTANT / CONSULTANT		DATE	
Author	R. Lizza	Date	_____
Approved	Project manager T. C. Ghimbali	Approved/Consultant	_____
Checked	Section Coordinator C. Ghimbali	Approved/Client	_____
Drawn	Total Project P. Amadio	Approved/Client	_____
Discussed	Projector _____	Approved/Client	_____
SUBCONSULTANT / SUBCONSULTANT			
Approved	Projector _____	Approved/Client	_____
Discussed	Subcontractor responsible _____	Approved/Client	_____

Realizarea liniei de cablu fibra optică - Serviciu parte componentă a contractului IV Pan European, per Secțiunea I Etapă - Serviciu - Serviciu
 Rehabilitation of the railway Pan-European - Serviciu parte componentă a contractului IV Pan European, per Secțiunea I Etapă - Serviciu - Serviciu
 Particular contract for the telecommunication system for the station and the communication system for the station and the communication system for the station
 Particular contract for the telecommunication system for the station and the communication system for the station and the communication system for the station

EA51	01	C	10	LX	TS	10	2	8	004	0
------	----	---	----	----	----	----	---	---	-----	---

Conditions / Condiții System: _____
 Scale: 1:50
 L07
 N. / Nr.: _____