

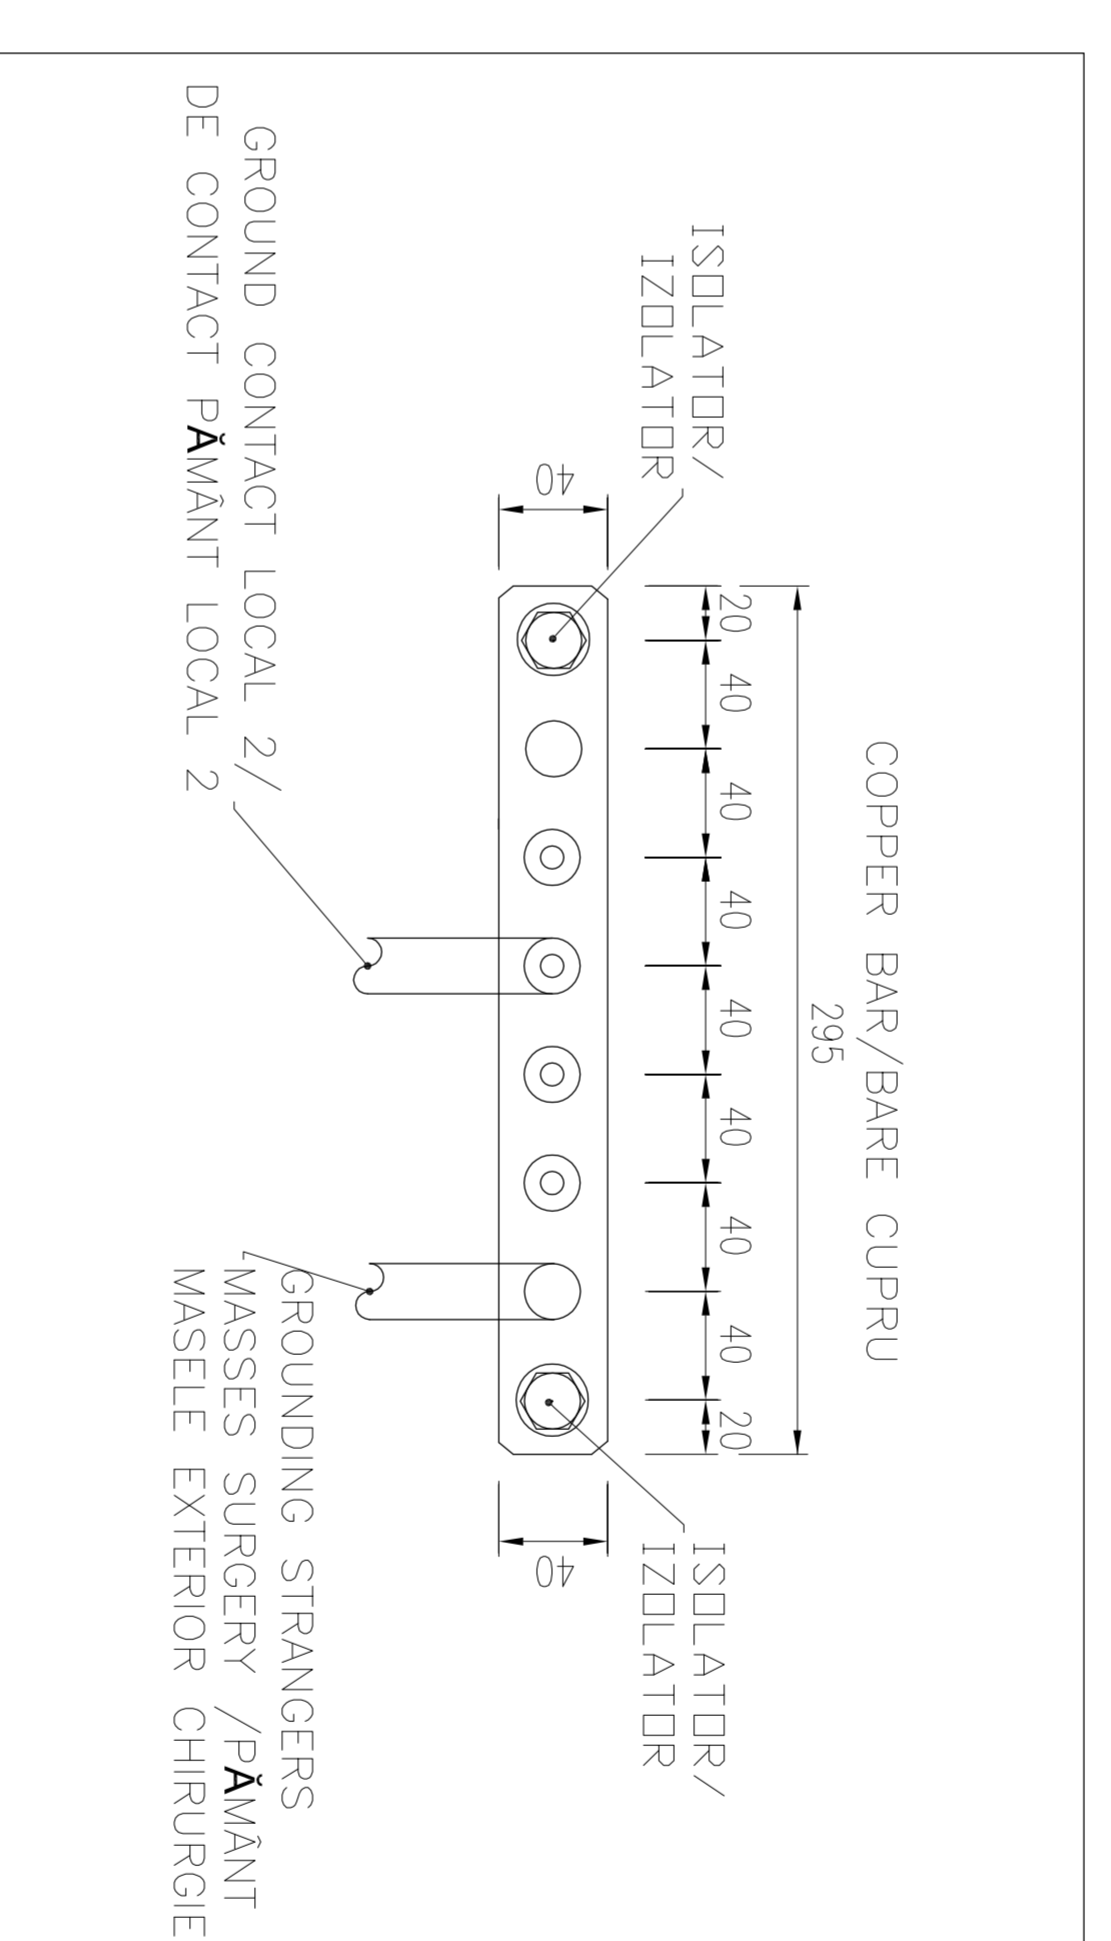
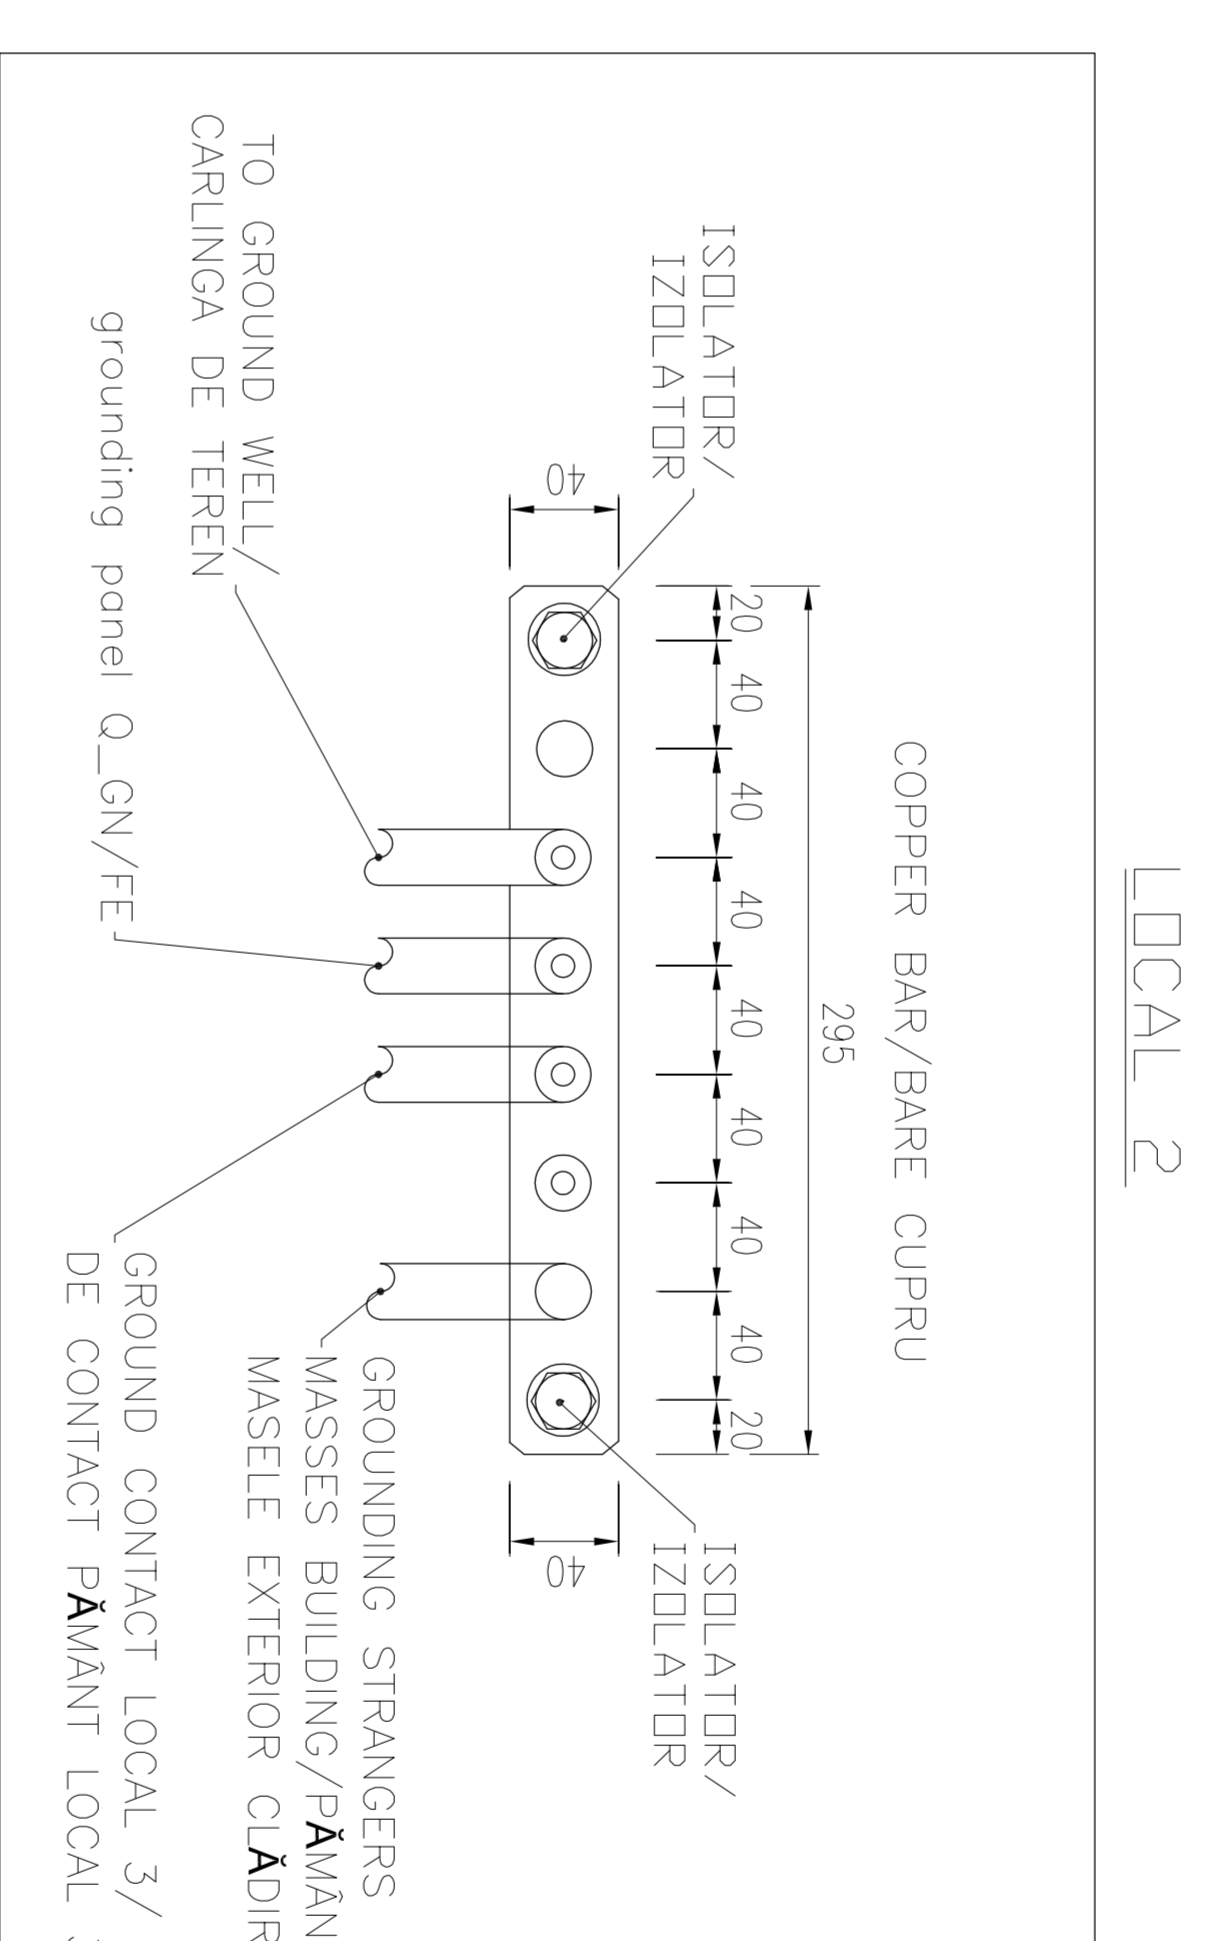


MEDICAL CARE BUILDING GROUND FLOOR PLAN/CLADIRE DE SANATATE PLAN DE PARTER - SCALE 1:50

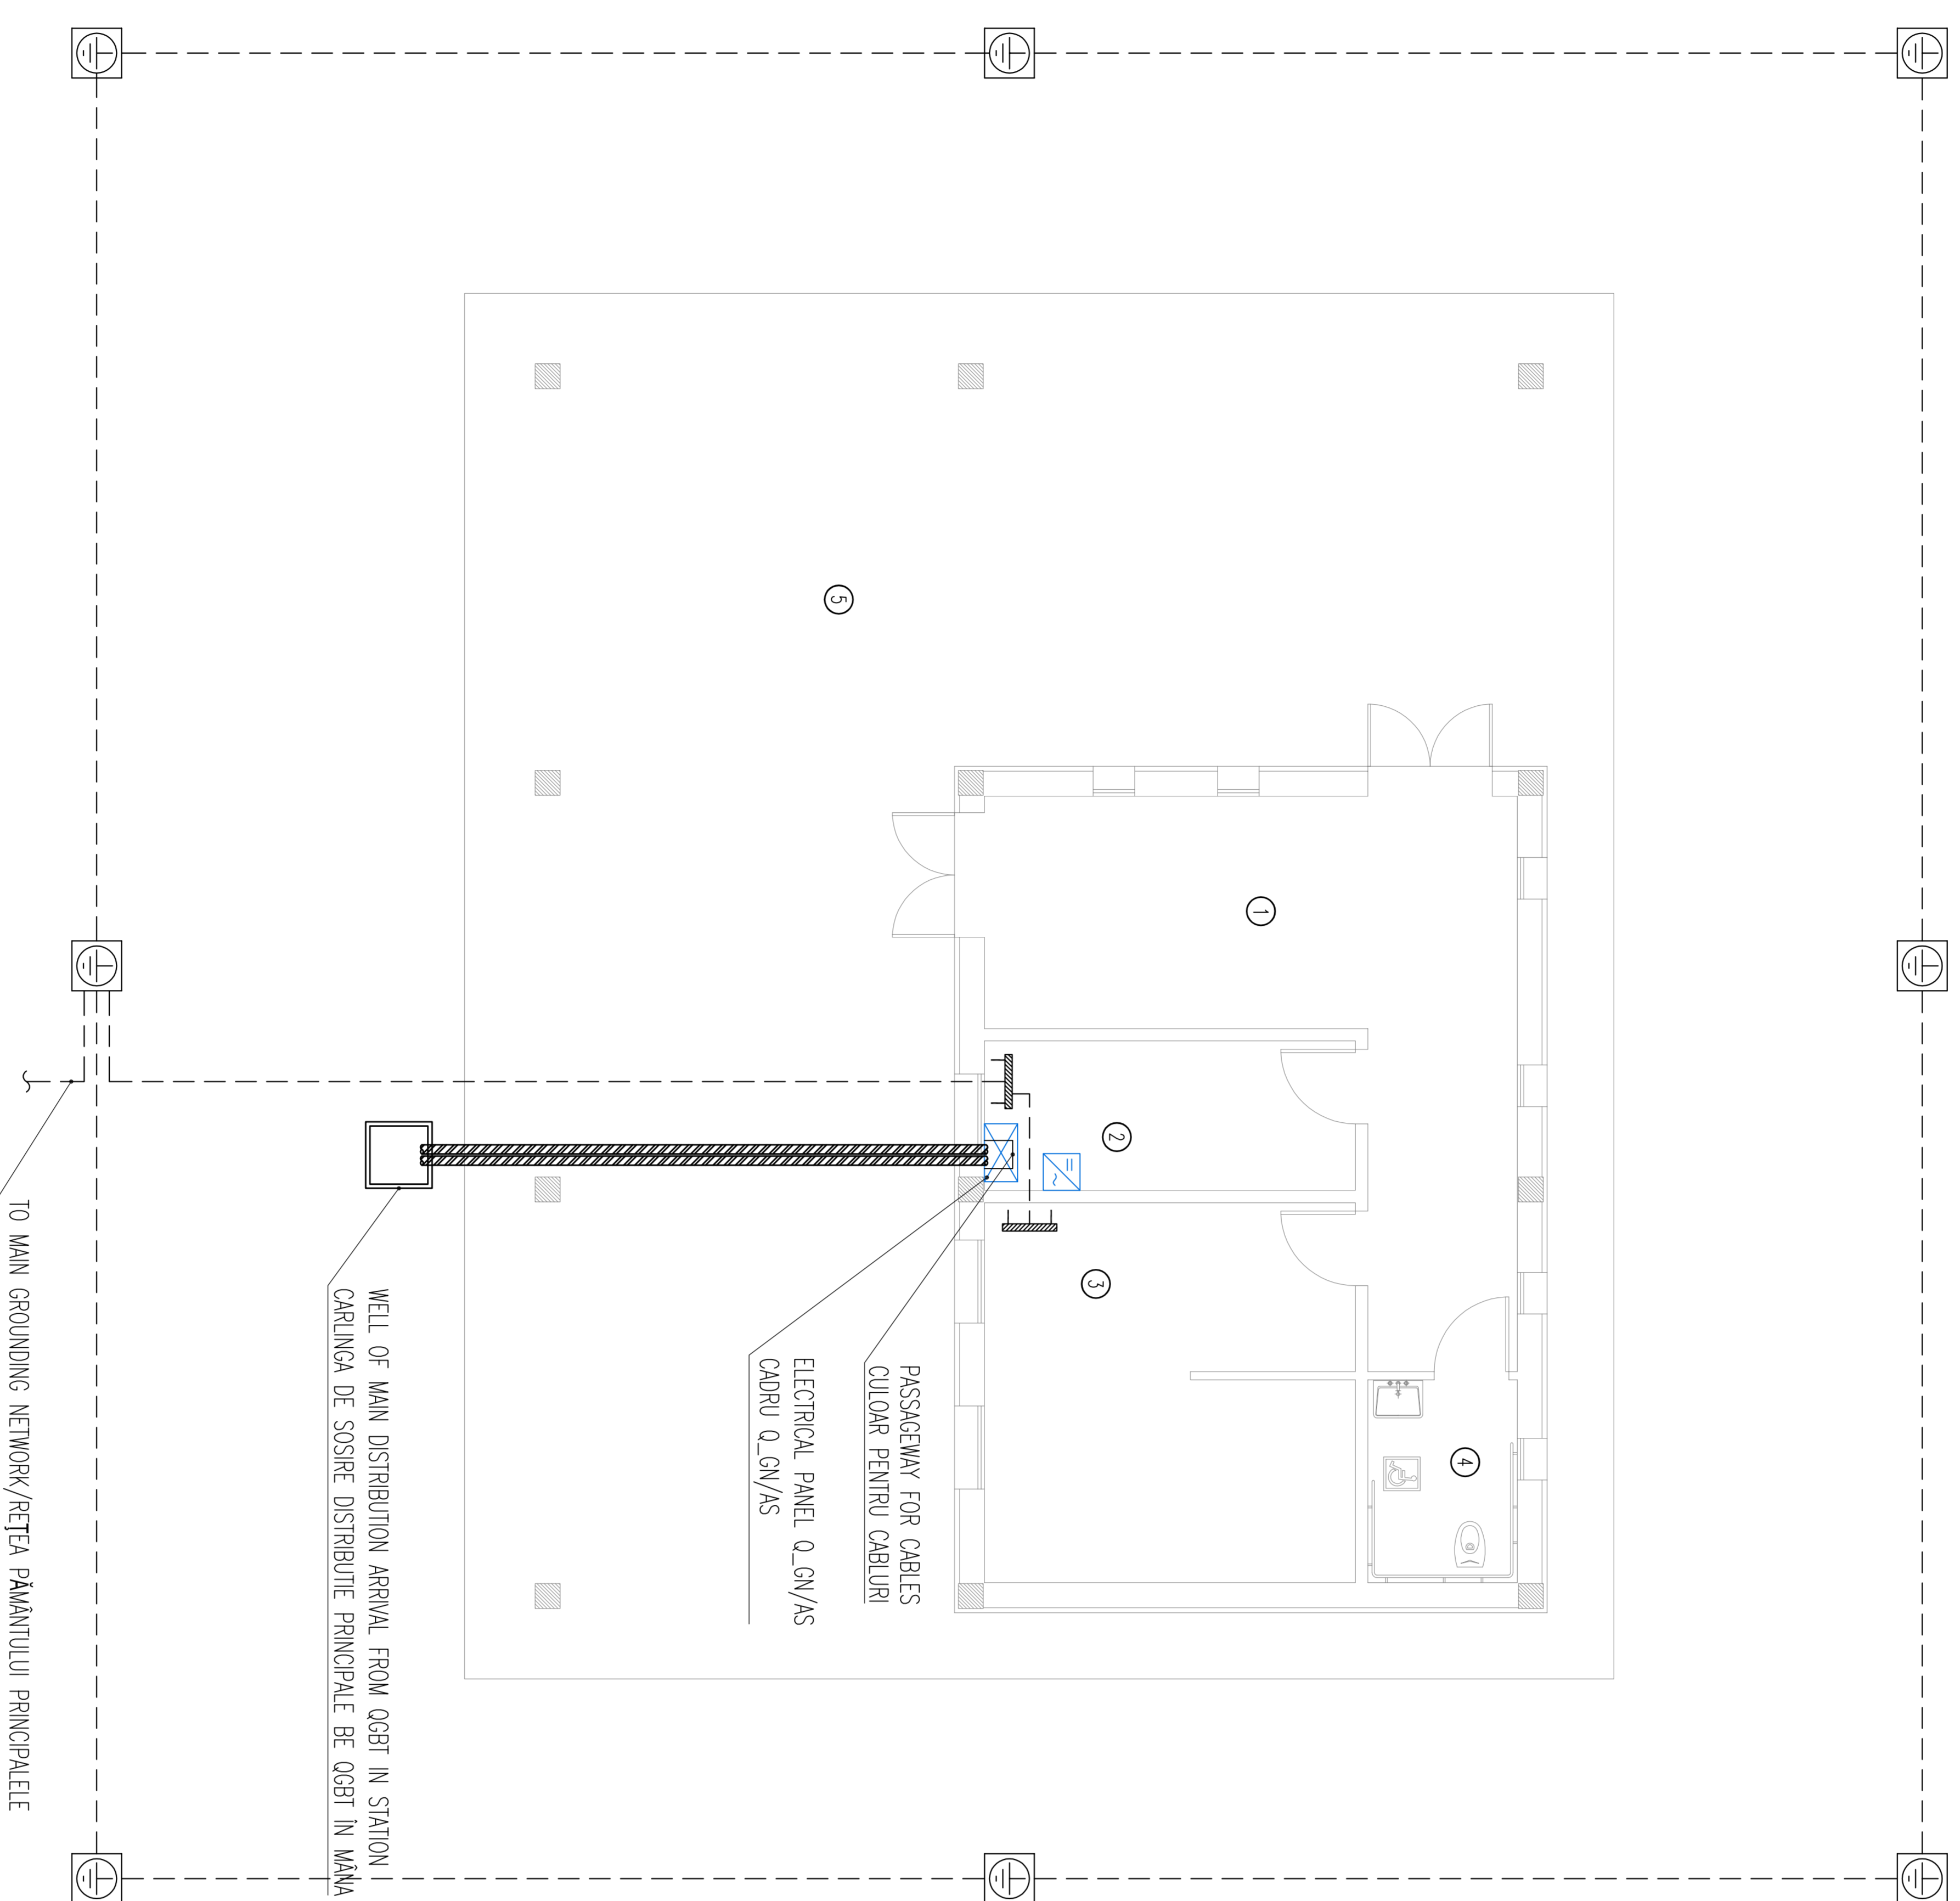


LOCAL	DESCRIPTION/DESCRIERE
1	WELLING LOCAL
2	LOCAL IN ZESTRARE
3	CHIRURGIE
4	W.C.
5	W.C./TOILET

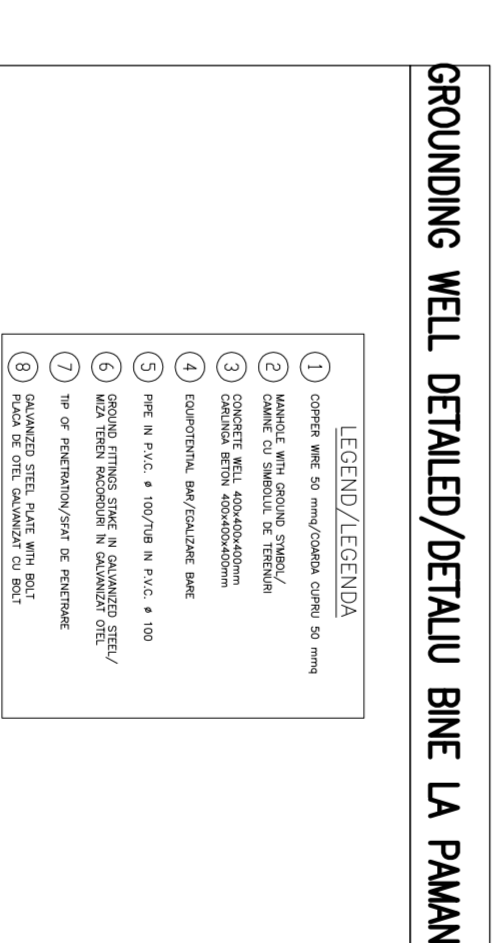


SYMBOLS LEGEND/LEGENDA SIMBOLOURI

SYMBOL/SIMBOLUL	DESCRIPTION/DESCRIERE
	ELECTRICAL PANEL/CADRU ELECTRICE
	WELL OF MAIN DISTRIBUTION ARRIVAL FROM COBET IN STATION 1
	CARRIAGE FOR DISTRIBUTING THE MAIN NETWORK
	GROUND INSUPPORTABLE WELL 400x400x400 mm WITH SINK
	BAR IN PATIENT INSPECT 400x400x400 mm CU CHIURURGIE
	COPPER WIRE 50 mm ² /CADRUL CUPRU 50 mm ²
	COPPER BAND 4x20 mm/banda cupru 4x20 mm
	COPPER EQUIPMENT BAR/ECHIZAJARE CUPRU BARE
	THREE PHASE WIRES FOR NETWORK CONNECTION CONNECTION DC-AC/INVERTOR TRII FAZE
	FERRULE RETACOLECTOARE DC-AC NOMINAL POWER 20W/nominal de alimentare 20W

KEY MAP/HARTA CHEIE

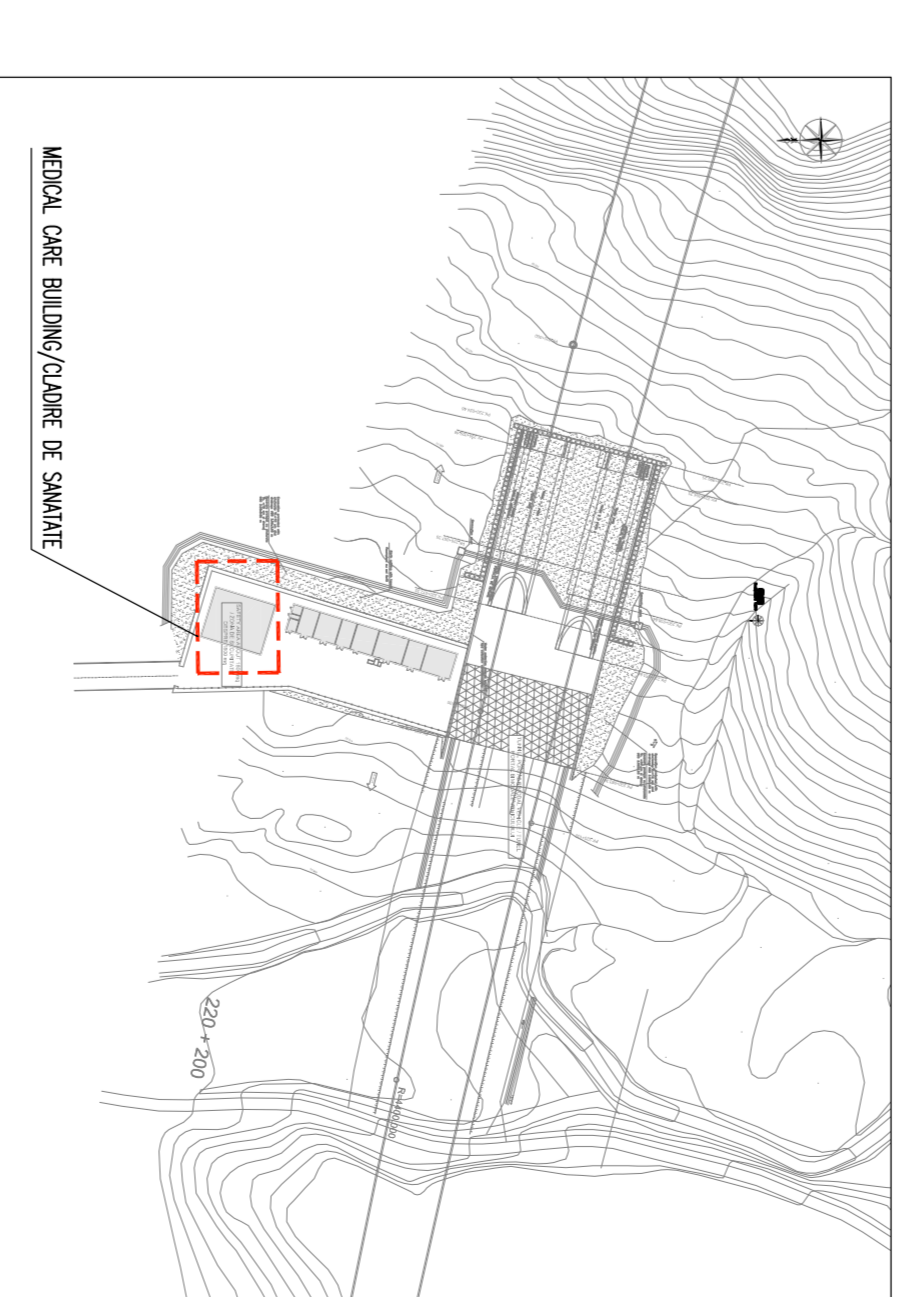

GROUNDING WELL DETAILED/DETALIU BUNE LA PAMANT

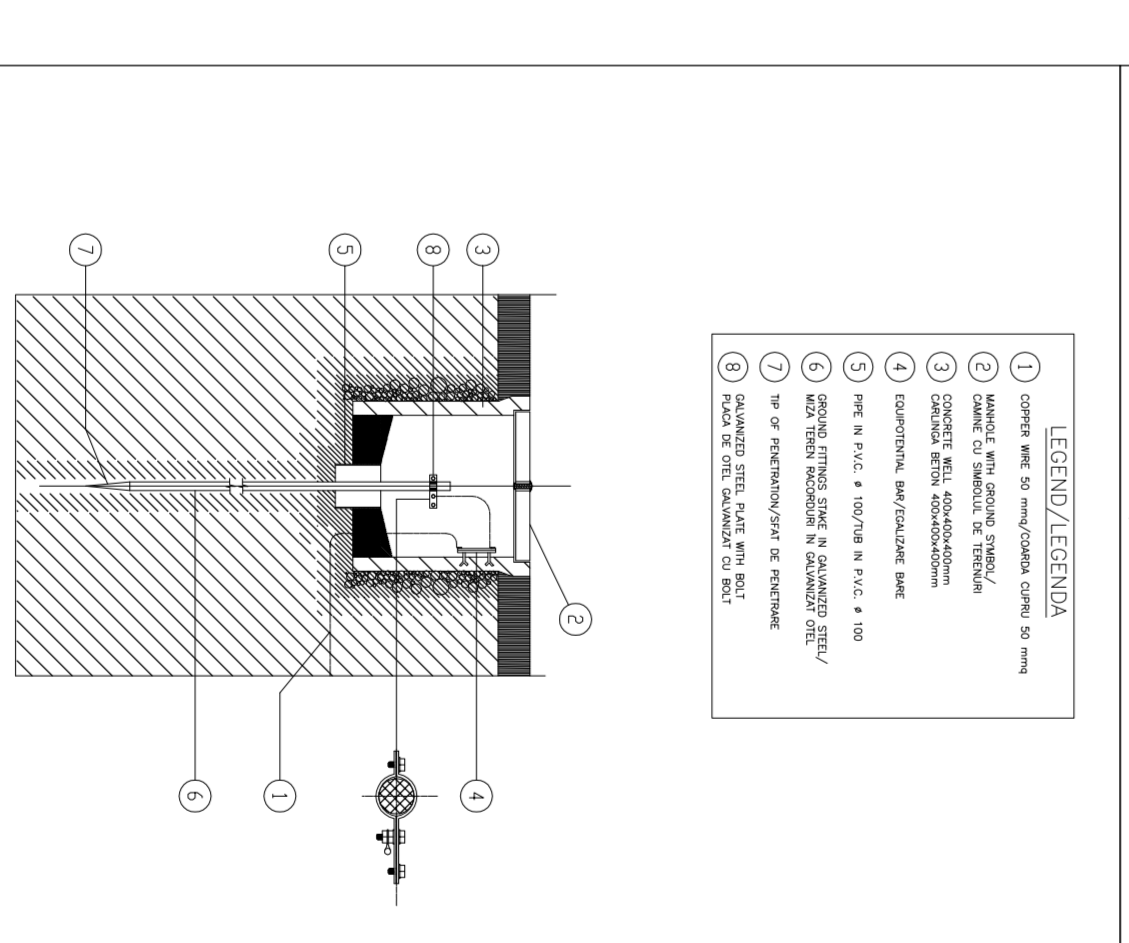

NO.	NAME	FUNCTION	DATE	STATUS
A	Author	Modificator/Modificator		
B	Designer	Proiectant		
C	Check	Verificator		
D	Approval	Modificator/Modificator		

CLIENT / CLIENT	CONSULTANT / CONSULTANT
<p>GOVERNUL ROMANIEI ROMANIAN GOVERNMENT</p> <p>PROIECT PAMANT DE IZOLARE EUROPEANA EUROPEAN INSULATION PROJECT</p> <p>C.N.C.F. "C.F.R." - S.A.</p>	<p>TECHNIC CONSULTANT</p> <p>OBERMAYER CONSULTANT</p> <p>WILSON CONSULTANT</p> <p>SASO CONSULTANT</p>

DATE	DESCRIPTION	BY	DATE	DESCRIPTION
2023/07/26/2023	Project/Proiect	SA	2023/07/26/2023	Project/Proiect
2023/07/26/2023	Design/Proiect	SA	2023/07/26/2023	Design/Proiect
2023/07/26/2023	Check/Verificare	SA	2023/07/26/2023	Check/Verificare
2023/07/26/2023	Approval/Approbarea	SA	2023/07/26/2023	Approval/Approbarea