
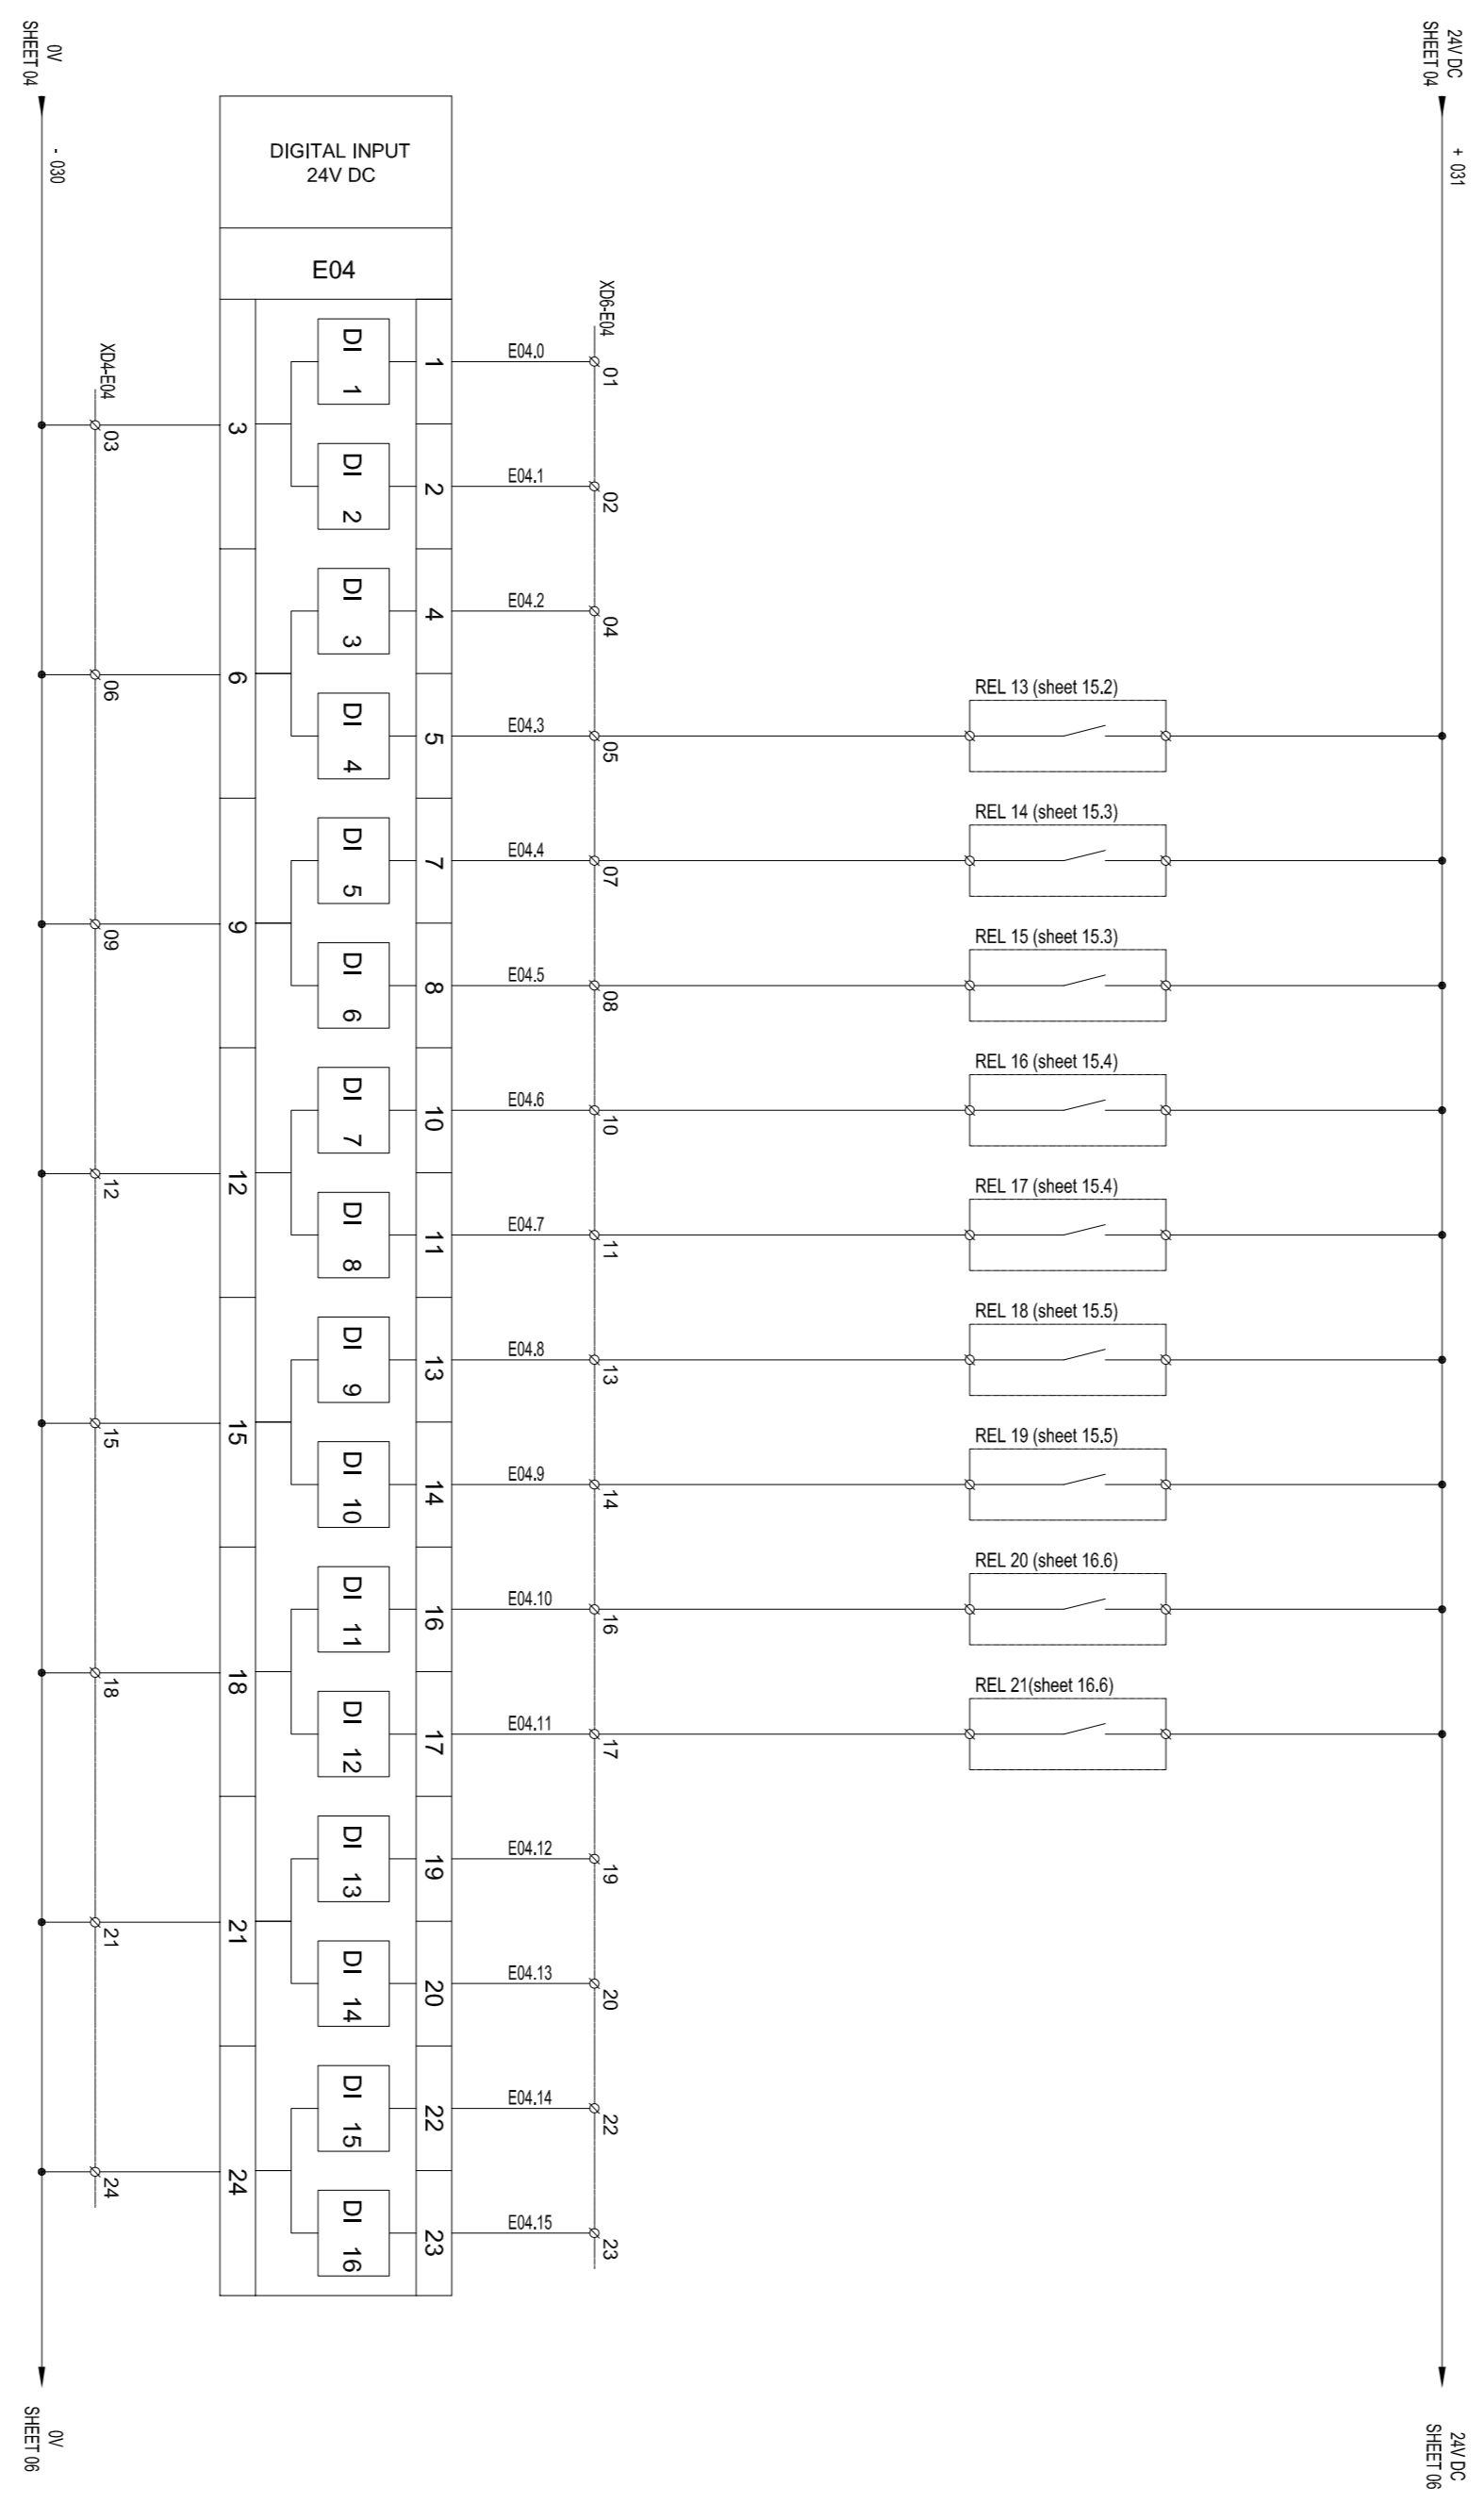


1 2 3 4 5 6 7 8 9 10

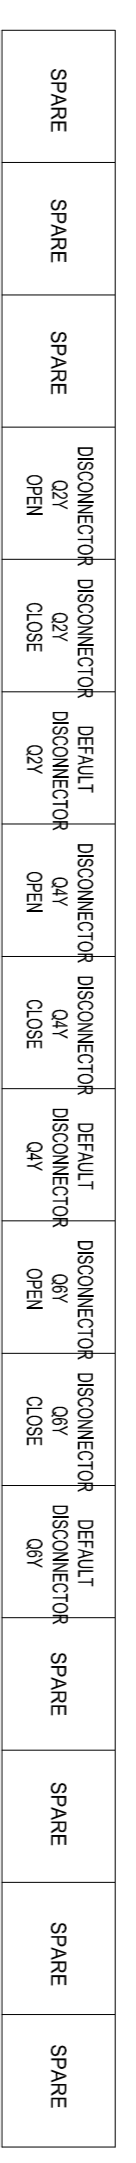

D					
C					
B					
A					
Index	Data	Modificare	Proiectant	Approbat Consultant	Approbat CFR
		Modificati/revisi	Designer	Approbat Consultant	Approbat CFR

GUVERNUL ROMANIEI
ROMANIAN GOVERNMENT

PROIECT FINANAT DE UNIUNEA EUROPEANA
EUROPEAN UNION FINANCED PROJECT



CLIENT / CLIENT

C.N.C.F. "C.F.R." - S.A.

Approbat	Subcontractant	Date	Semnatura
Approved	Subcontractor responsible	Date	Signature
Approbat	Responsabil Subcontractant	11.2011	R. Lutzza
Approved	Subcontractor responsible	11.2011	C. Gambelli
Verificat	Expert Chief	11.2011	G. Bulfirih
Checked	Key Expert		

SUBCONTRACTANT / SUBCONTRACTOR

RESPONSABIL SUBCONTRACTANT

A. Stanescu - Dinulescu

Redistributie liniei de cale ferata Brasov - Sibiu, parte componenta a conditiilor IV Pan European, pentru circulatia trenurilor cu viteza maxima de 160 km/h.

Rehabilitation of the railway line Brasov - Sibiu, part of the IV Pan-European Corridor, for the trains circulation with maximum speed of 160 km/h.

Section : Brasov - Sibiu/soara

Denumire desen / Drawing Title :

STATIA CF ARCHITA/ ARCHITRA RAILWAY STATION

CIRCUITE SECUNDARE/SECONDARY CIRCUITS

SCHEMA DE COMANDA SEPARATOARE

DISCONNECTORS REMOTE CONTROL DIAGRAM

Codificare / Codification System	Scara / Scale	LOT/LOT	Nr / No
E A S I	0 1	E	1 5
	D X	E G	0 0
			8
			6
			0 0 3
			1