


stația c.f.-ARCHITA /railway station

CONTRACTOR NO.01 OPEN	CONTRACTOR NO.02 CLOSE	TRIPERSON TUX REVERSAL BREAKER	ZEMACON TDY PANEL	DOOR OPEN TDY PANEL	COMMAND OPEN CONTRACTOR NO.0	COMMAND CLOSE CONTRACTOR NO.0
--------------------------	---------------------------	--------------------------------------	----------------------	------------------------	------------------------------------	-------------------------------------

Diagram DRC cu automata programabilă
DRC panel with programmable logic controller
(Incluziunea de comandă a aspersoarelor
în funcționarea de către controler programabil)

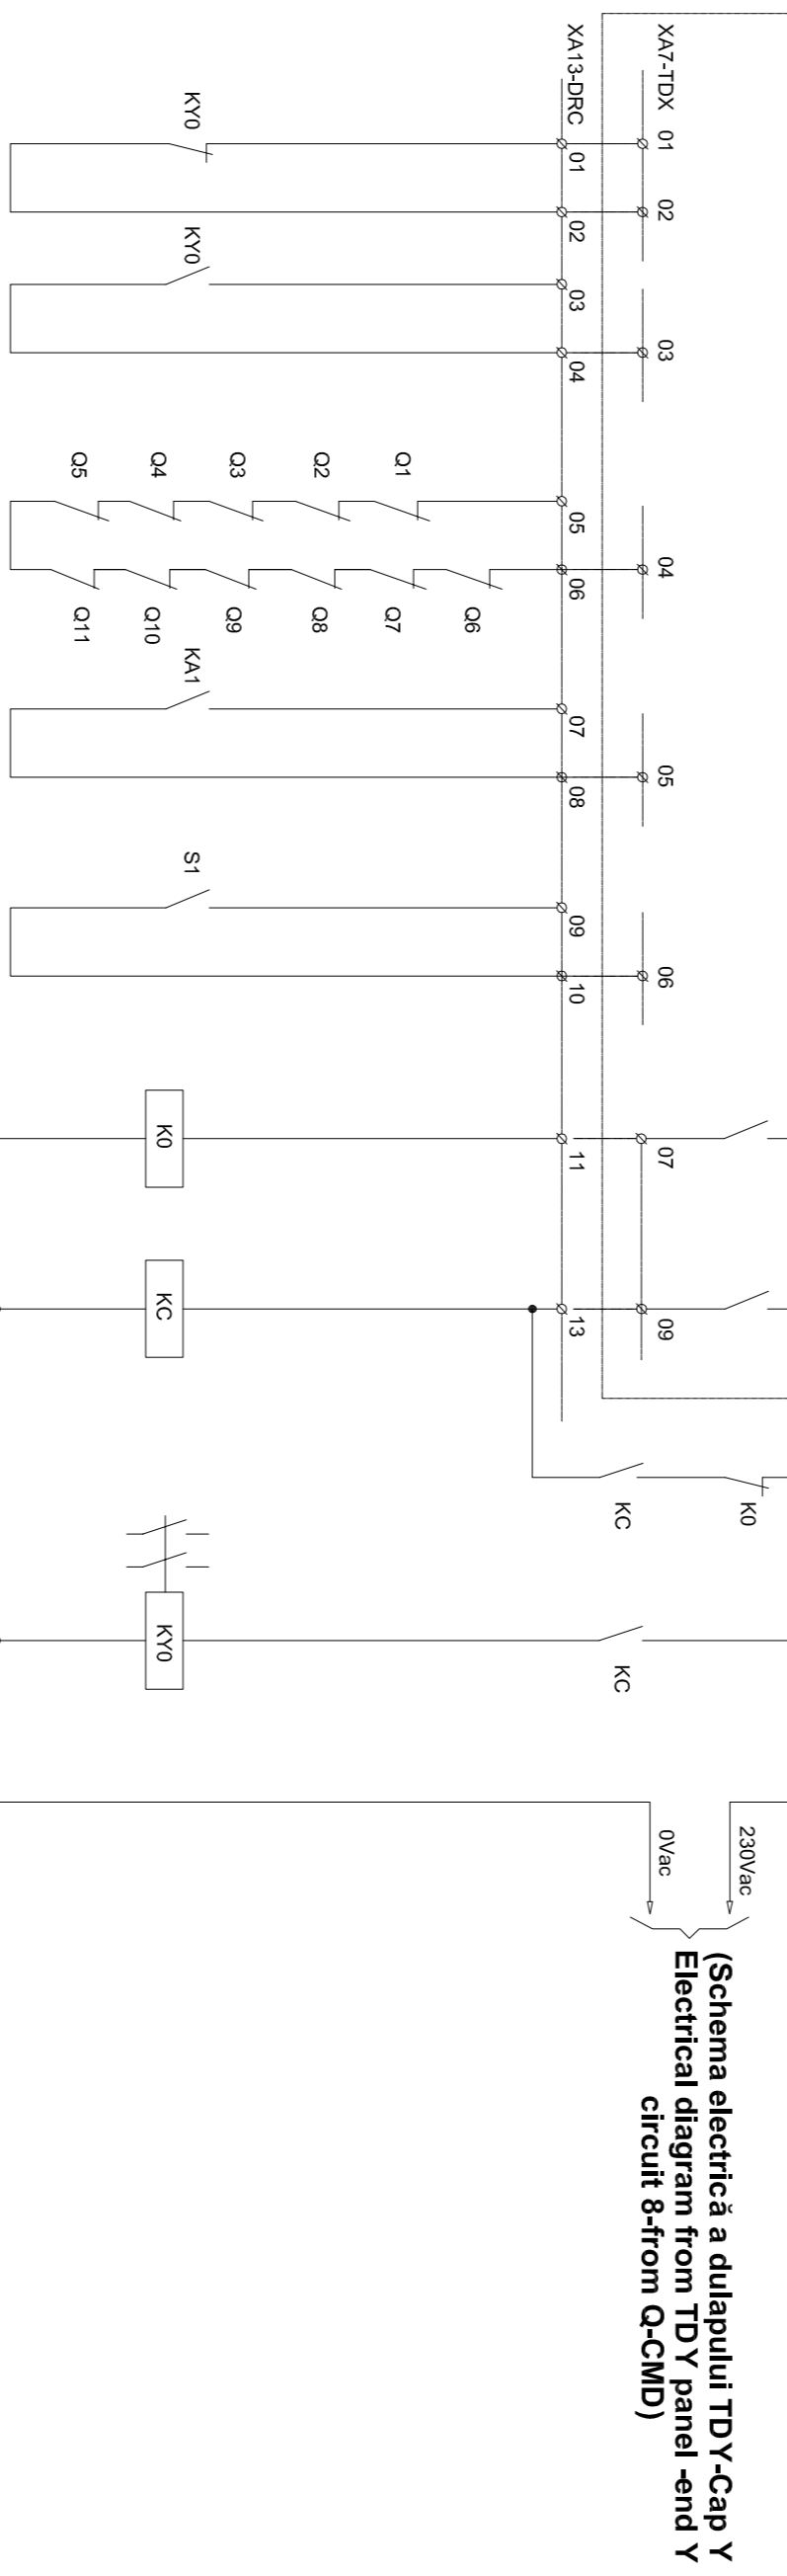

(Schema electrică a dulapului TDY-Cap Y
Electrical diagram from TDY panel -end Y
circuit 3)

(Schema electrică a dulapului TDY-Cap Y
Electrical diagram from TDY panel -end Y
circuit 5)

(Schema electrică a dulapului TDY-Cap Y
Electrical diagram from TDY panel -end Y
circuit 10)

(Schema electrică a dulapului TDY-Cap Y
Electrical diagram from TDY panel -end Y
circuit 8-from Q-CMD)

D					
C					
B					
A					
Index	Data	Modificare	Proiectant	Approbat	Approbat CFR
		Modificatori/Revision	Designer	Approved Consultant	Approved CFR

GUVERNUL ROMÂNIEI
ROMANIAN GOVERNMENT

PROIECT FINANȚAT DE UNIUNEA EUROPEANĂ
EUROPEAN UNION FINANCED PROJECT

CLIENT / CLIENT

C.N.C.F. "C.F.R." - S.A.

CONSULTANT / CONSULTANT

HALPERN
SCOTT
WILSON

OBERMEYER
PLANNING + DESIGN GMBH

TECNIC
CONSULTING ENGINEERS

Approbat	Șef proiect	R. Lutzza	Data	11.2011	Semnatura
Approbat	Proiectant	C. Gambailli	Data	11.2011	Signature
Verificat	Coordonator Secțiune 1	G. Bulfărini	Data	11.2011	Signature
Verificat	Expert Chief				
Checked	Key Expert				

Approbat	Responsabil Subcontractant	A. Stancu - Dinulescu	Data	11.2011	Signature
Verificat	Subcontractor responsible	M. Priporeanu	Data	11.2011	Signature

Redabiliteaza liniei de cale ferata Brasov - Sibieria, parte componentă a coridorului IV Pan European, pentru circulația trenurilor cu viteză maximă de 160 km/h.
Rehabilitation of the railway Brasov - Sibieria - component part of the IV Pan-European Corridor, for the trains circulation with maximum speed of 160 km/h.
Section : Brasov - Sibierscra

Denumire desen / Drawing Title :
STAȚIA c.f. ARCHITA/ ARCHITA RAILWAY STATION
SCHEMA DE COMANDĂ ÎNCĂLZIRE ELECTRICE A MACAZURILOR -cap Y
CONTROL DIAGRAM FROM HEATERS-end Y

Codificare / Codification System	Scara / Scale	LOT / LOT	Nr / No
E A S I 1 0 1 E 1 5 D X E G 0 0 8 5 0 0 3 1			01 / 01