


1 2 3 4 5 6 7 8 9 10

DISCONNECTOR Q1X OPEN	DISCONNECTOR Q1X CLOSE	DEFAULT DISCONNECTOR Q1X	DISCONNECTOR Q3X OPEN	DISCONNECTOR Q3X CLOSE	DEFAULT DISCONNECTOR Q3X	DISCONNECTOR Q5X OPEN	DISCONNECTOR Q5X CLOSE	DEFAULT DISCONNECTOR Q5X	SWITCH SS12 OPEN	SWITCH SS12 CLOSE	DEFAULT SWITCH SS12	DISCONNECTOR S12 OPEN	DISCONNECTOR S12 CLOSE	DEFAULT DISCONNECTOR S12	SPARE
-----------------------	------------------------	--------------------------	-----------------------	------------------------	--------------------------	-----------------------	------------------------	--------------------------	------------------	-------------------	---------------------	-----------------------	------------------------	--------------------------	-------

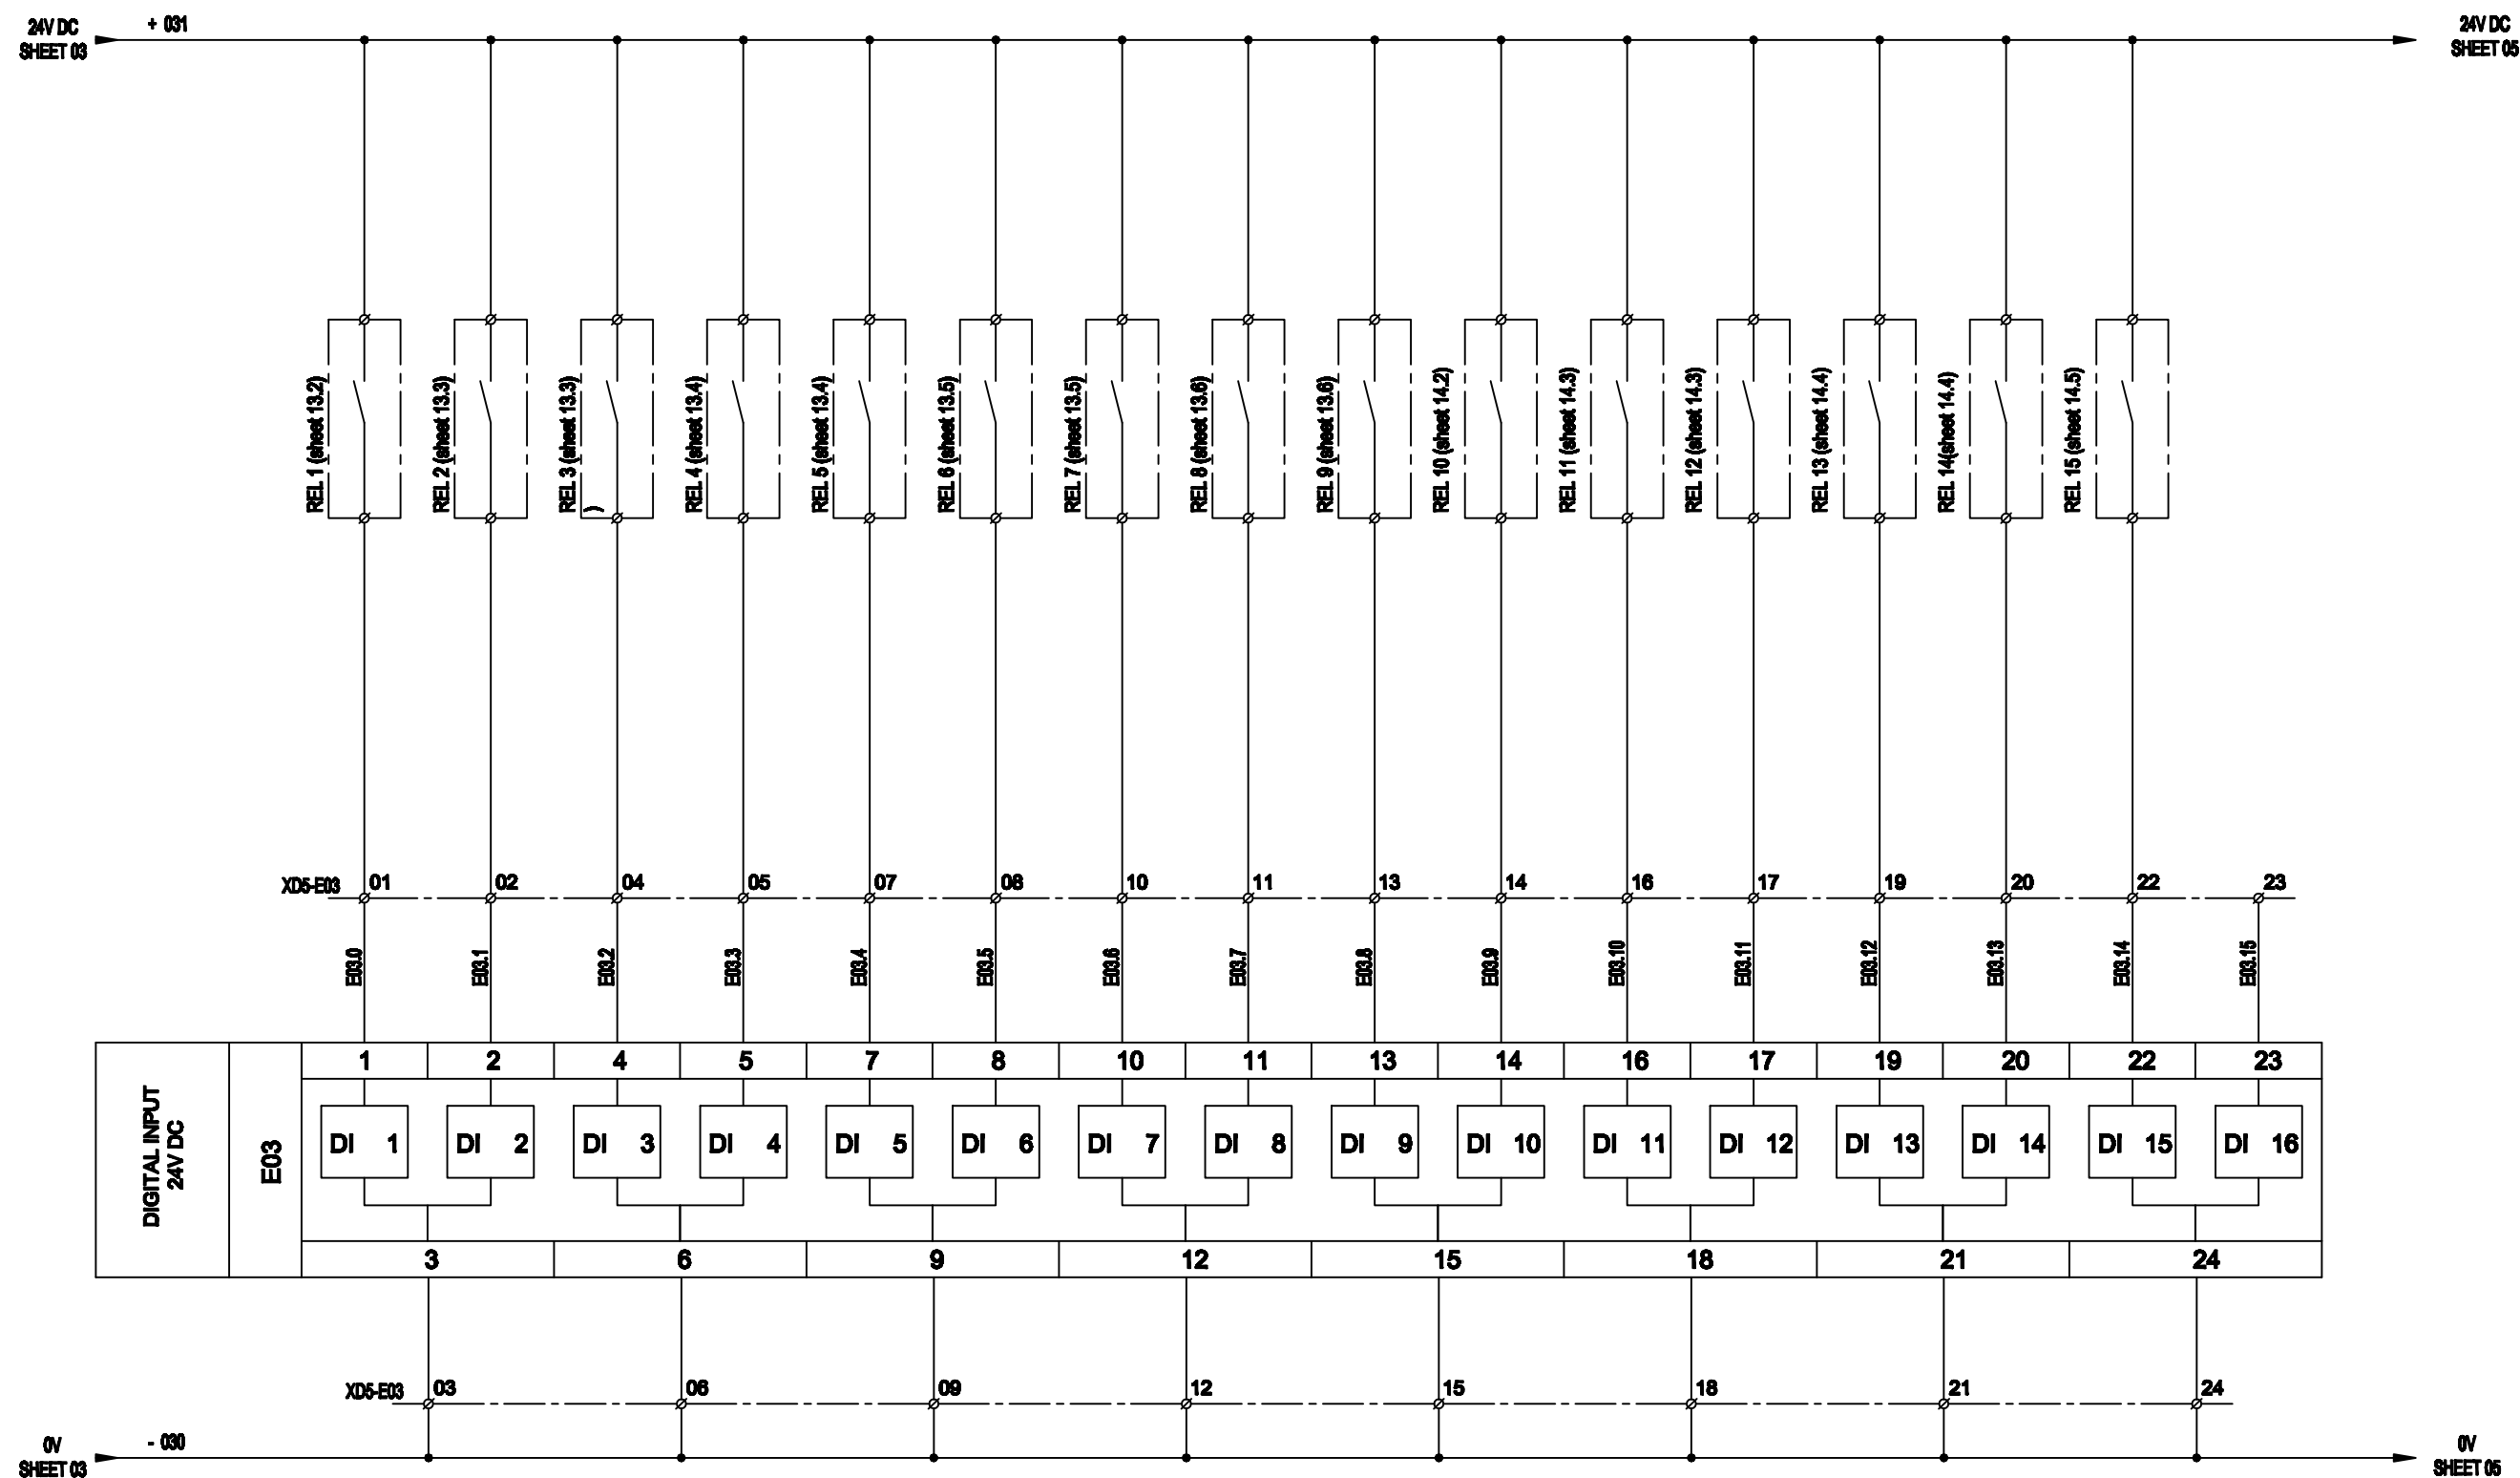

D					
C					
B					
A					
Indice Index	Data Date	Modificare Modification/Revision	Proiectant Designer	Aprobat Consultant Approved Consultant	Aprobat CFR Approved CFR



ERNUL ROMANIEI
NIAN GOVERNMENT

PROIECT FINANȚAT DE UNIUNEA EUROPEANĂ
EUROPEAN UNION FINANCED PROJECT



C.N.C.F. "C.F.R." - S.A.

CLIENT / CLIENT



CONSULTANT / CONSULTANT

Aprobat Approved	Șef proiect Project manager	R. Liuzza	Data Date	Semnătură Signature
Aprobat Approved	Coordonator Secțiune 1 Section 1 Coordinator	C. Gambelli	11.2011	<i>C. Gambelli</i>
Verificat Checked	Expert Verificator Checking Expert	G. Buffarini	11.2011	<i>G. Buffarini</i>

SUBCONTRACTANT / SUBCONTRACTOR

Aprobat Approved	Responsabil Subcontractant Subcontractor Responsible	A.Stanciu - Dinulescu	Data Date	Semnătură Signature
Întocmit Elaborated	Proiectant Designer	M. Priporeanu	11.2011	<i>M. Priporeanu</i>

Reabilitarea liniei de cale ferată Brașov - Simeria, parte componentă a coridorului IV Pan European, pentru circulația trenurilor cu viteză maximă de 160 km/h,
Tronsonul : Brașov - Sighișoara
Rehabilitation of the railway line Brașov - Simeria, component Part of the IV Pan-European Corridor, for the trains circulation with maximum speed of 160 km/h,
Section : Brașov - Sighișoara

Proiect/Project
2004/RO/16/PIPA/003
Faza / Phase:
P.Th. / T.D.

Denumire desen / Drawing Title :
STAȚIA c.f. ALBEȘTI/ ALBEȘTI RAILWAY STATION
CIRCUITE SECUNDARE/SECONDARY CIRCUITS
SCHEMA DE COMANDĂ SEPARATOARE
DISCONNECTORS REMOTE CONTROL DIAGRAM

Codificare / Codification System	Scara / Scale	LOT / LOT	Nr. / No
	1:1		04 / 18

EA51 01 E 19 DX EG 00 2 6 005 0